

CLIENT INFORMATION

CORPORATE HEADQUARTERS
F11B1T


DESIGNER INFORMATION

KALI STEELE
STEELE DESIGN FIRM
9850 PAGEDWOOD LANE
HOUSTON, TX 77042
STEELEDESIGNFIRM@GMAIL.COM
405-655-5917

SHEET INDEX

CS	COVER SHEET
ID-1	FLOOR PLAN
ID-2	FURNITURE AND POWER PLAN
ID-3	REFLECTED CEILING PLAN
ID-4	FINISH PLAN
ID-5	FINISH SCHEDULE
ID-6	ELEVATIONS
ID-7	DETAILS

LOCATION

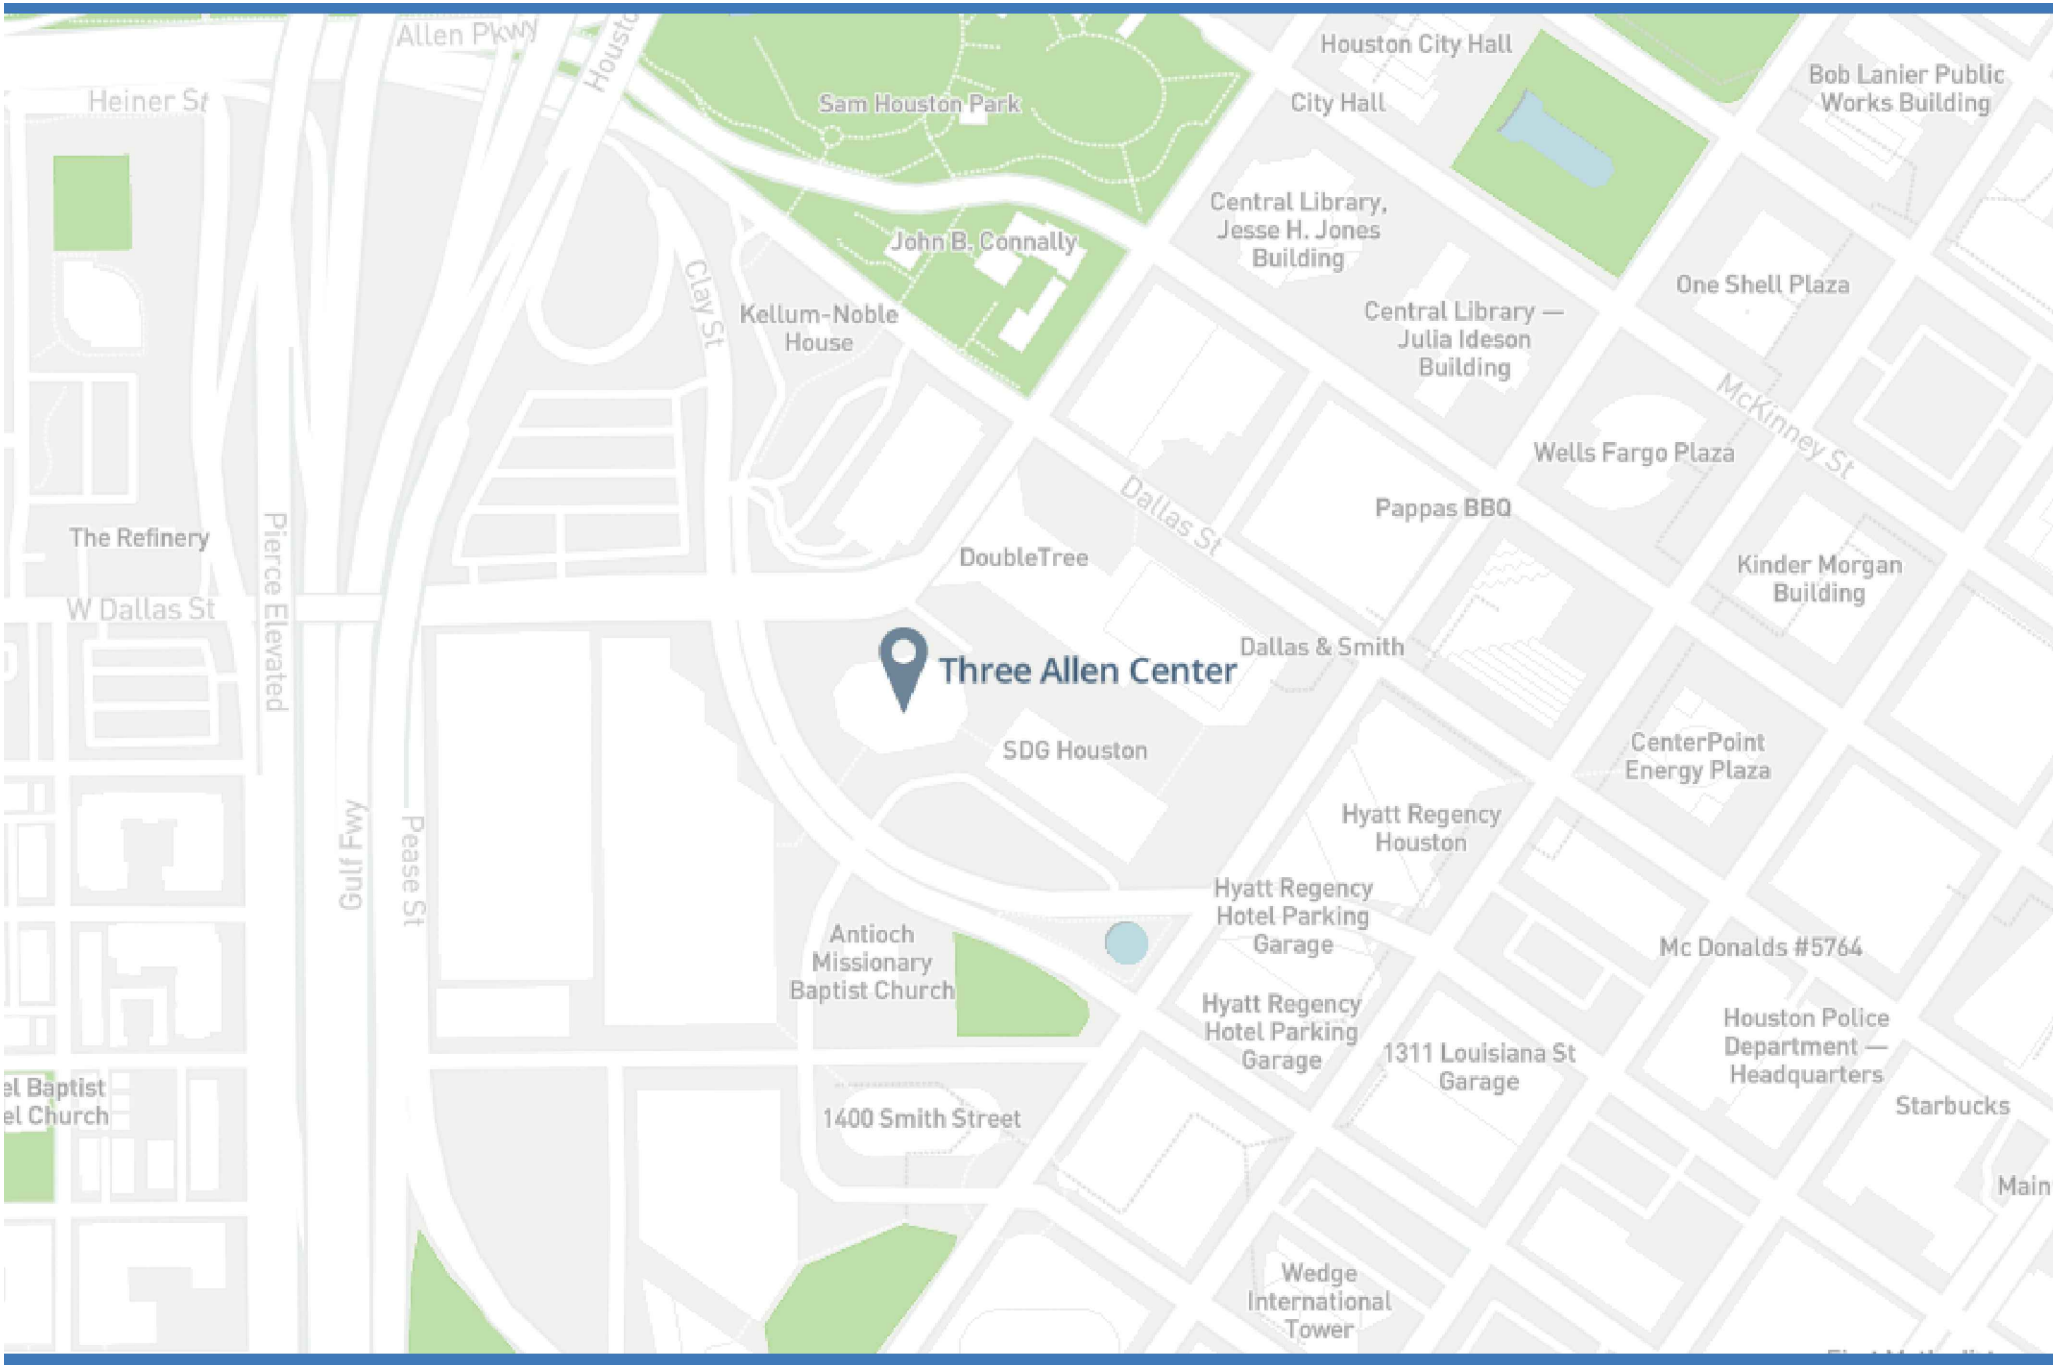

PROJECT:
F11B1T CORPORATE OFFICE
333 CLAY STREET SUITE 3700
HOUSTON TX 77002

COMMERCIAL DESIGN
INDS 1345

REVISIONS		
6		
5		
4		
3		
2		
1		


DATE: 01 / 23 / 2021

DRAFTED BY:
KALI
STEELE

SHEET CONTENTS:
COVER SHEET

SHEET:
CS

PRODUCED BY AN AUTODESK STUDENT VERSION

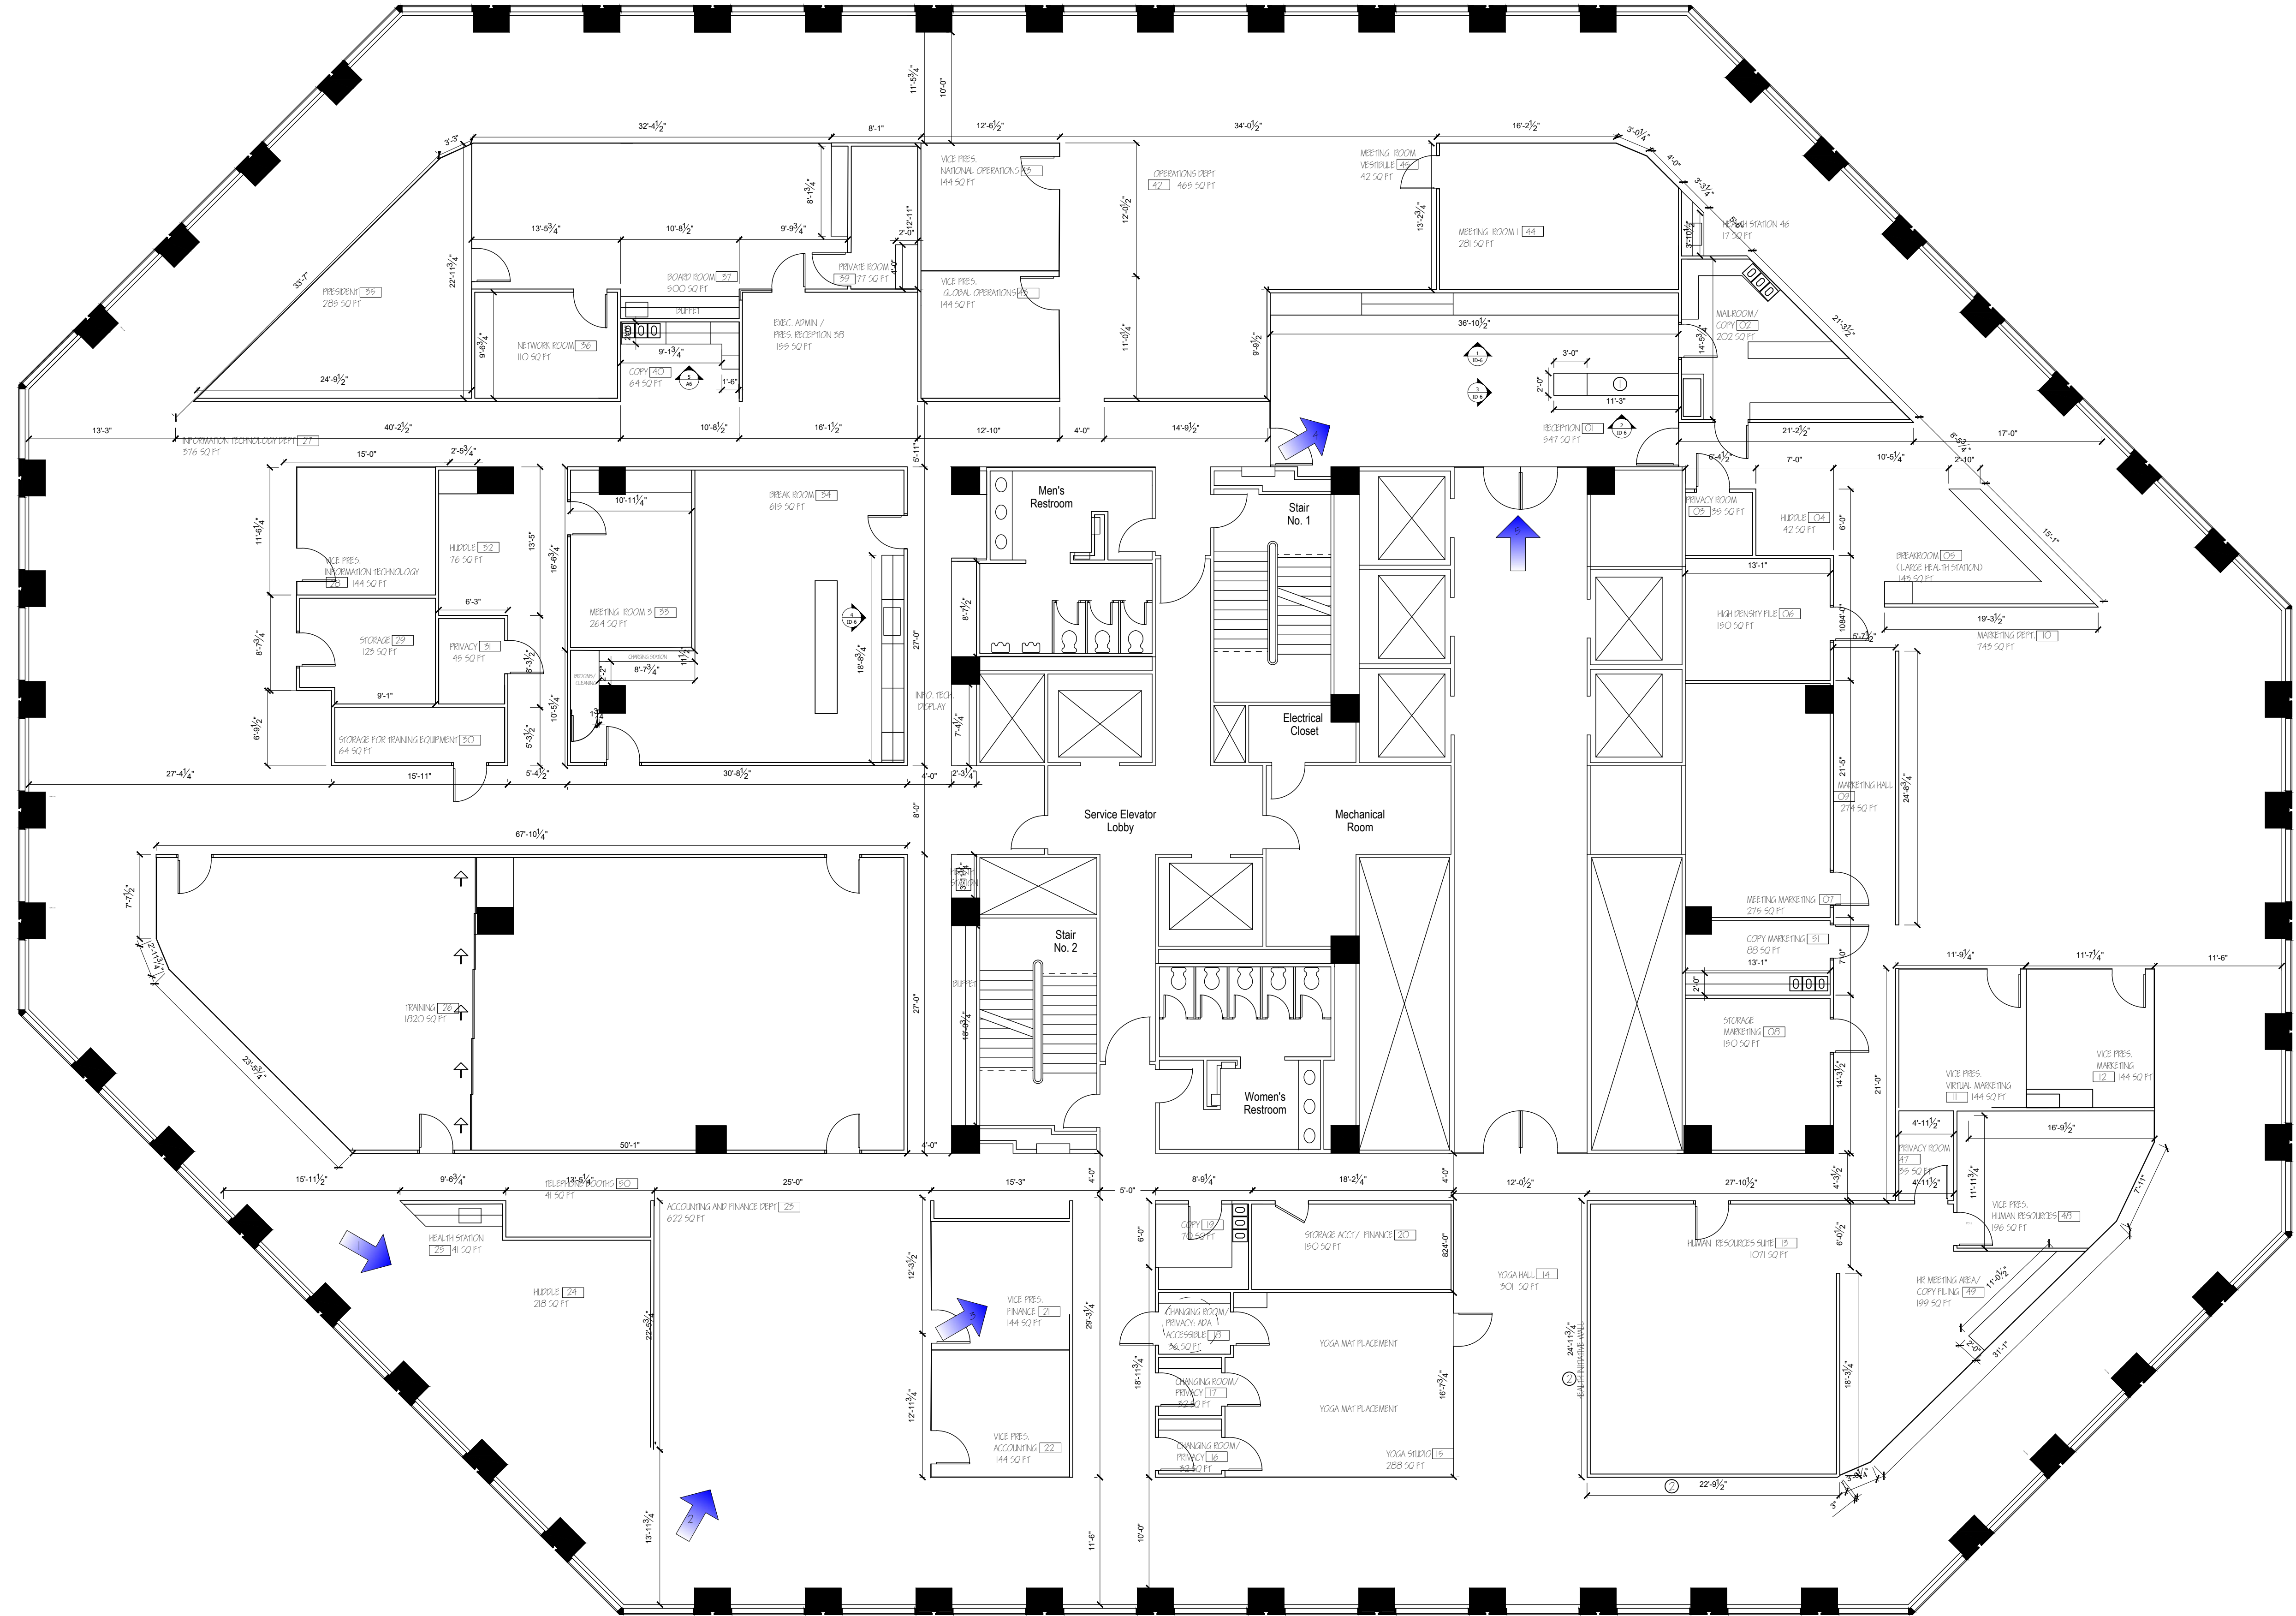

1 ARCHITECTURAL FLOOR PLAN
SCALE: 1/8" = 1'-0"

- GENERAL NOTES:
1. ALL MILLWORK TO BE V.I.F.
 2. ALL DOORS ARE 3'-0" WIDTH
 3. ALL INTERIOR GLAZING IS 1/2" THICK
 4. ALL INTERIOR WALLS (GYPSUM BOARD) ARE 3.5" THICK.
 5. SEE NOTED ELEVATIONS FOR DETAILS

- LOCAL NOTES:
1. CUSTOM MILLWORK RECEPTION DESK. SEE DETAILS ON A.6
 2. TRANSOM GLAZING ABOVE

LEGEND

- NORTH ARROW
- ELEVATION TAG
- DIMENSION STRING
- CENTER LINE
- PERSPECTIVE



PROJECT:
F11B1T CORPORATE OFFICE
333 CLAY STREET SUITE 3700
HOUSTON TX 77002

COMMERCIAL DESIGN
INDS 1345


REVISIONS		
6		
5		
4		
3		
2		
1		

DATE: 01/23/2021


DRAFTED BY:
KALI STEELE

SHEET CONTENTS:
ARCHITECTURAL
FLOOR PLAN

SHEET:
1D-1

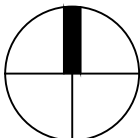

PRODUCED BY AN AUTODESK STUDENT VERSION

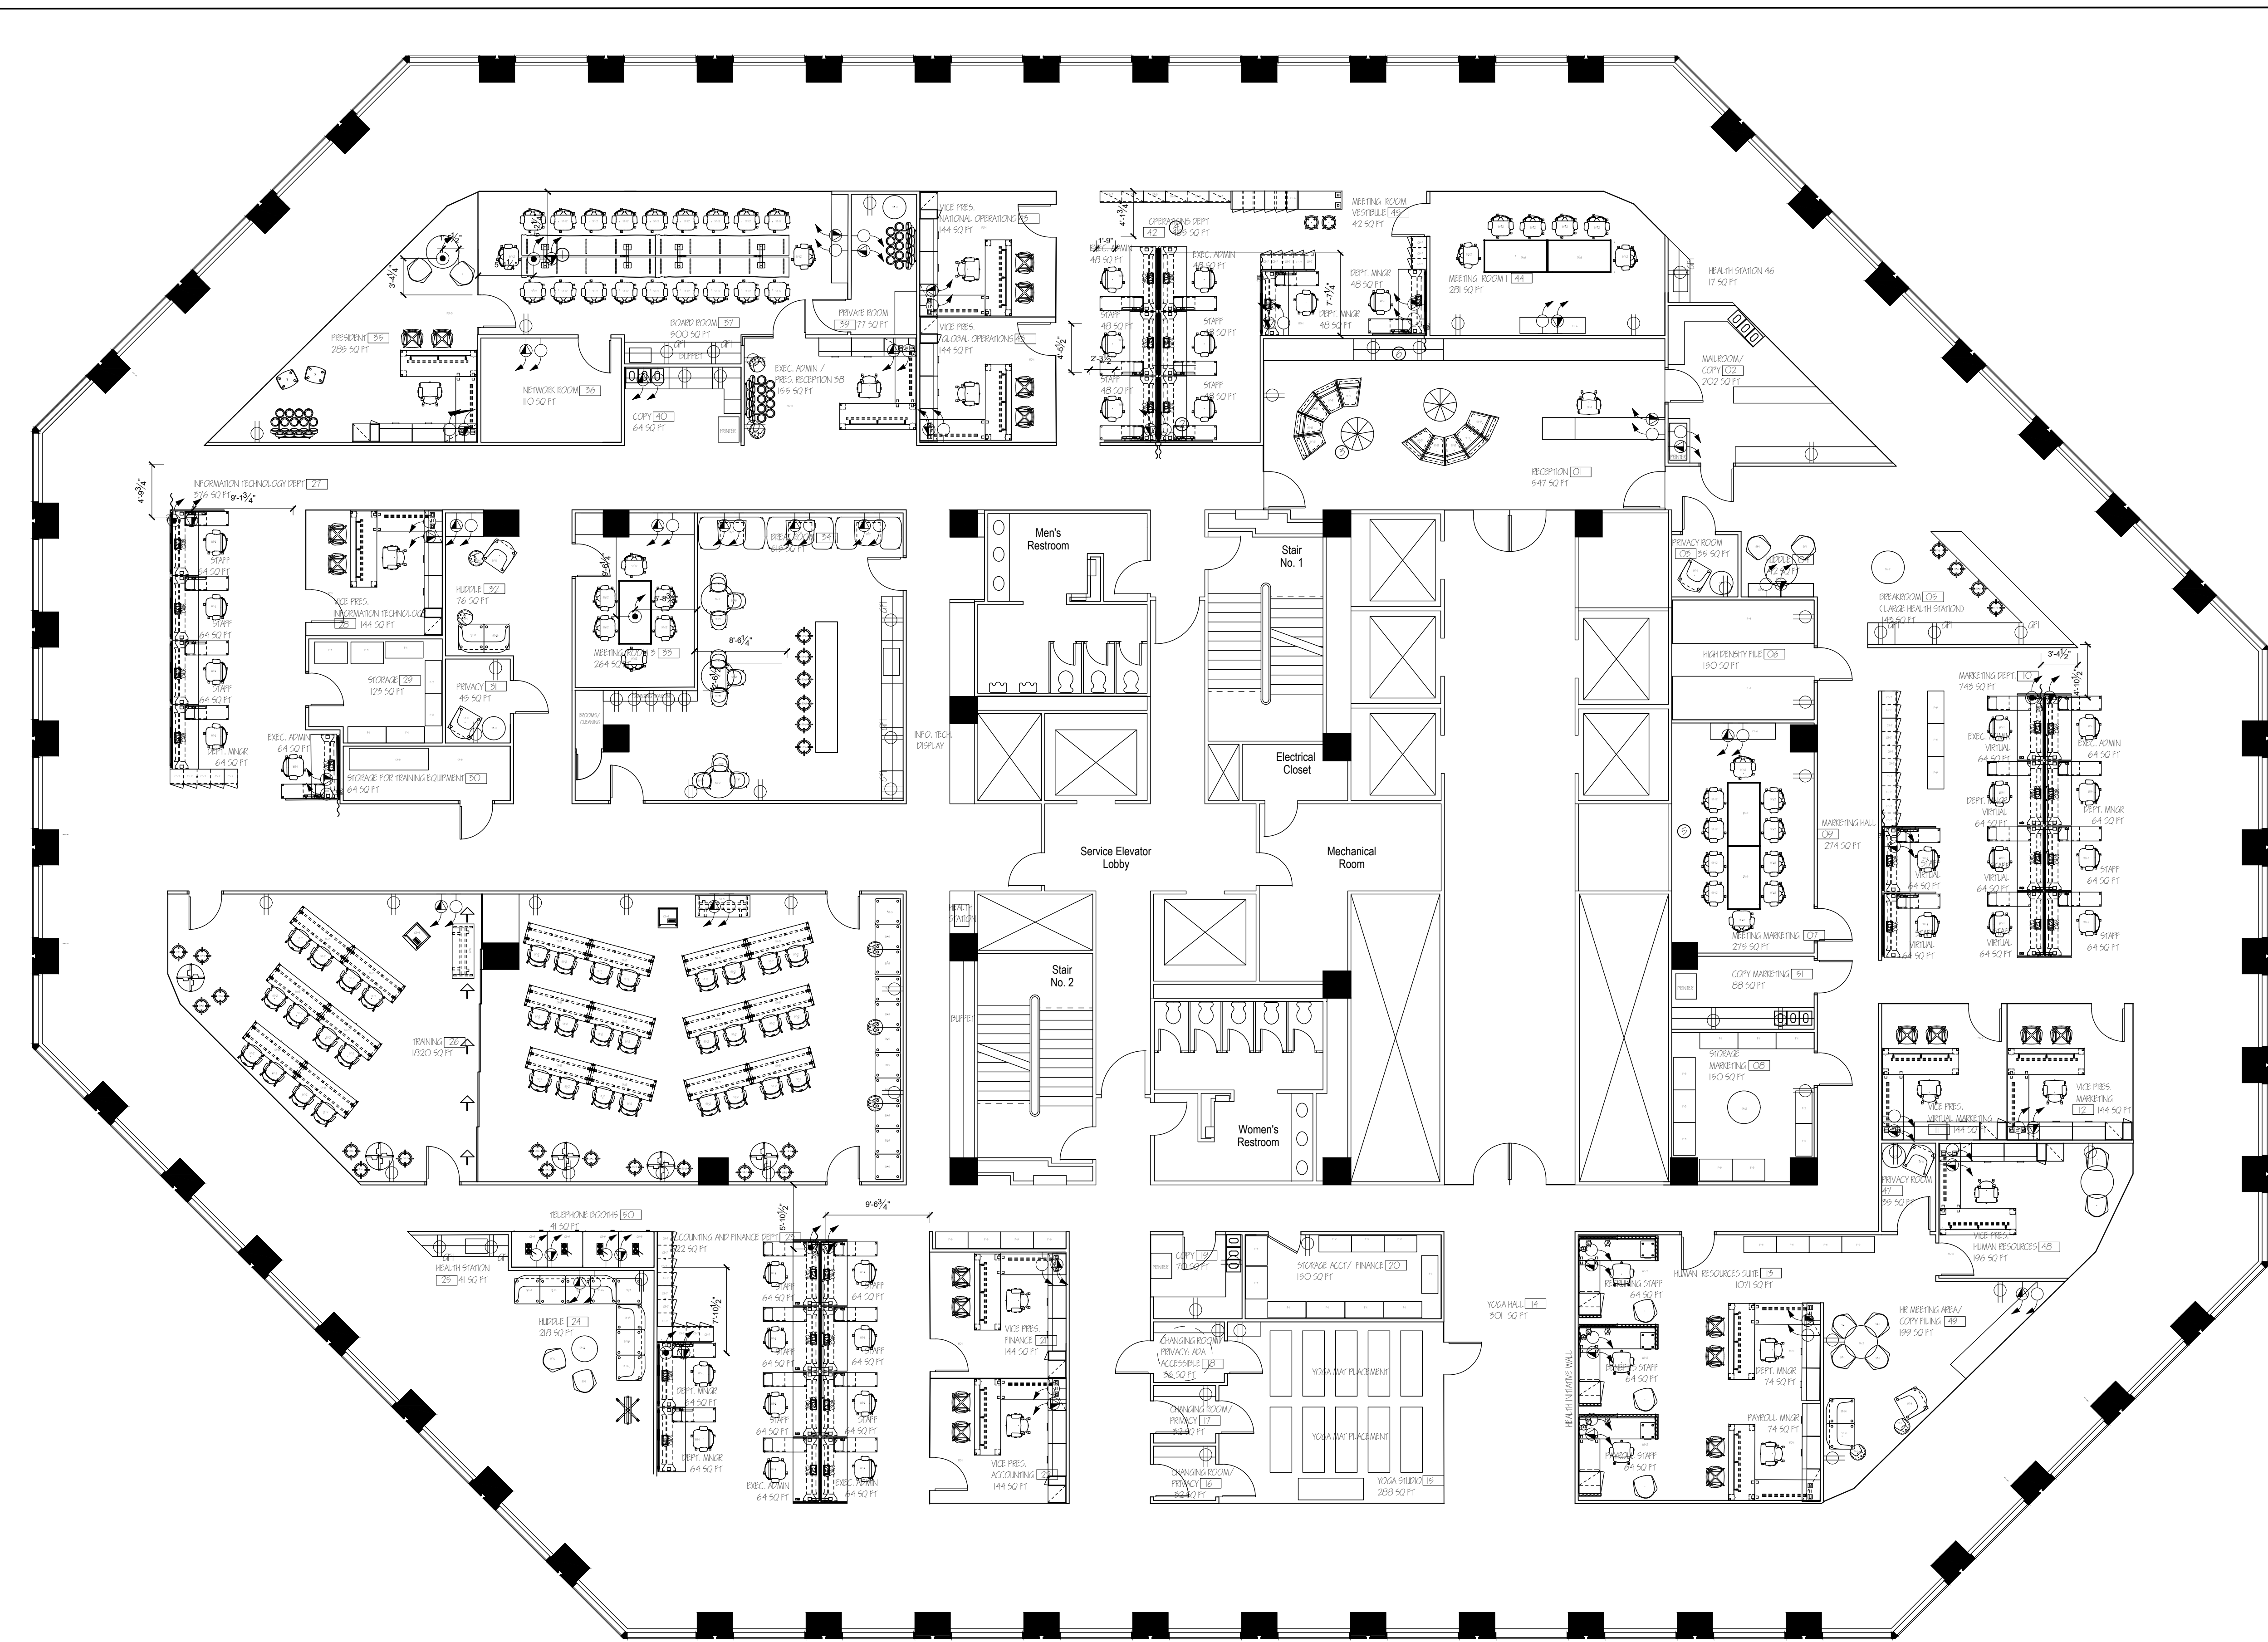

1 FURNITURE AND POWER PLAN
SCALE: 1/8" = 1'-0"

- GENERAL NOTES:
1. ALL MILLWORK TO BE V.I.F.
 2. ALL DOORS ARE 3'-0" WIDTH
 3. ALL INTERIOR GLAZING IS 1/2" THICK
 4. ALL INTERIOR WALLS (GYPSUM BOARD) ARE 3/5" THICK.
 5. SEE NOTED ELEVATIONS FOR DETAILS
 6. ALL WALL OUTLETS TO BE MOUNTED AT 15" AFF EXCEPT WHERE LOCATED ABOVE COUNTERTOPS, THEN THEY SHALL BE 42" AFF. REFER TO ELEVATIONS FOR TYPICALS.
 7. ALL SWITCHES TO BE MOUNTED AT 36" AFF U.N.O.

- LOCAL NOTES:
1. CUSTOM BOARDROOM DESK WITH POWER CHANNEL. SEE PAGE A.6 FOR DETAILS
 2. ALL WORKSTATIONS (WS) AND PRIVATE OFFICES (PO) COME AS A "PACKAGE". REFER TO FURNITURE SPECIFICATION FOR ITEMS LISTED.
 3. EACH FURNITURE PIECE IS LABELED AS ST (SEATING), TA (TABLE), CS (CASEGOODS), AND F (FILING). REFER TO FURNITURE SPECIFICATION PACKAGE FOR DETAILS.
 4. EACH WORKSTATION IS LABELED WITH THE EMPLOYEE JOB AND SQ FT FOR THAT AREA. THE WHOLE DEPARTMENT, WITH CASEGOODS, CIRCULATION, AND WORKSTATION INCLUDED IS LABELED WITH THE TOTAL SQUARE FOOTAGE.
 5. PINABLE WALLS
 6. CUSTOM MILLWORK- STORAGE AND HOSPITALITY BAR

POWER LEGEND

	VOICE / DATA OUTLET		WALL MOUNTED JUNCTION BOX
	DUPLEX OUTLET		WALL MOUNTED HARDWIRED SYSTEMS FURNITURE POWER / VOICE / DATA
	GFI DUPLEX OUTLET		FLOOR MOUNTED HARDWIRED SYSTEMS FURNITURE POWER / VOICE / DATA
	DEDICATED DUPLEX OUTLET		FLOOR MOUNTED HARDWIRED SYSTEMS FURNITURE POWER

PROJECT:
11BIT CORPORATE OFFICE
333 CLAY STREET SUITE 3700
HOUSTON TX 77002

COMMERCIAL DESIGN
INDS 1345

REVISIONS		
6		
5		
4		
3		
2		
1		

DATE: 01 / 23 / 2021


DRAFTED BY:
KALI STEELE

SHEET CONTENTS:
FURNITURE
AND POWER
PLAN

SHEET:
1D-2

PRODUCED BY AN AUTODESK STUDENT VERSION

PRODUCED BY AN AUTODESK STUDENT VERSION

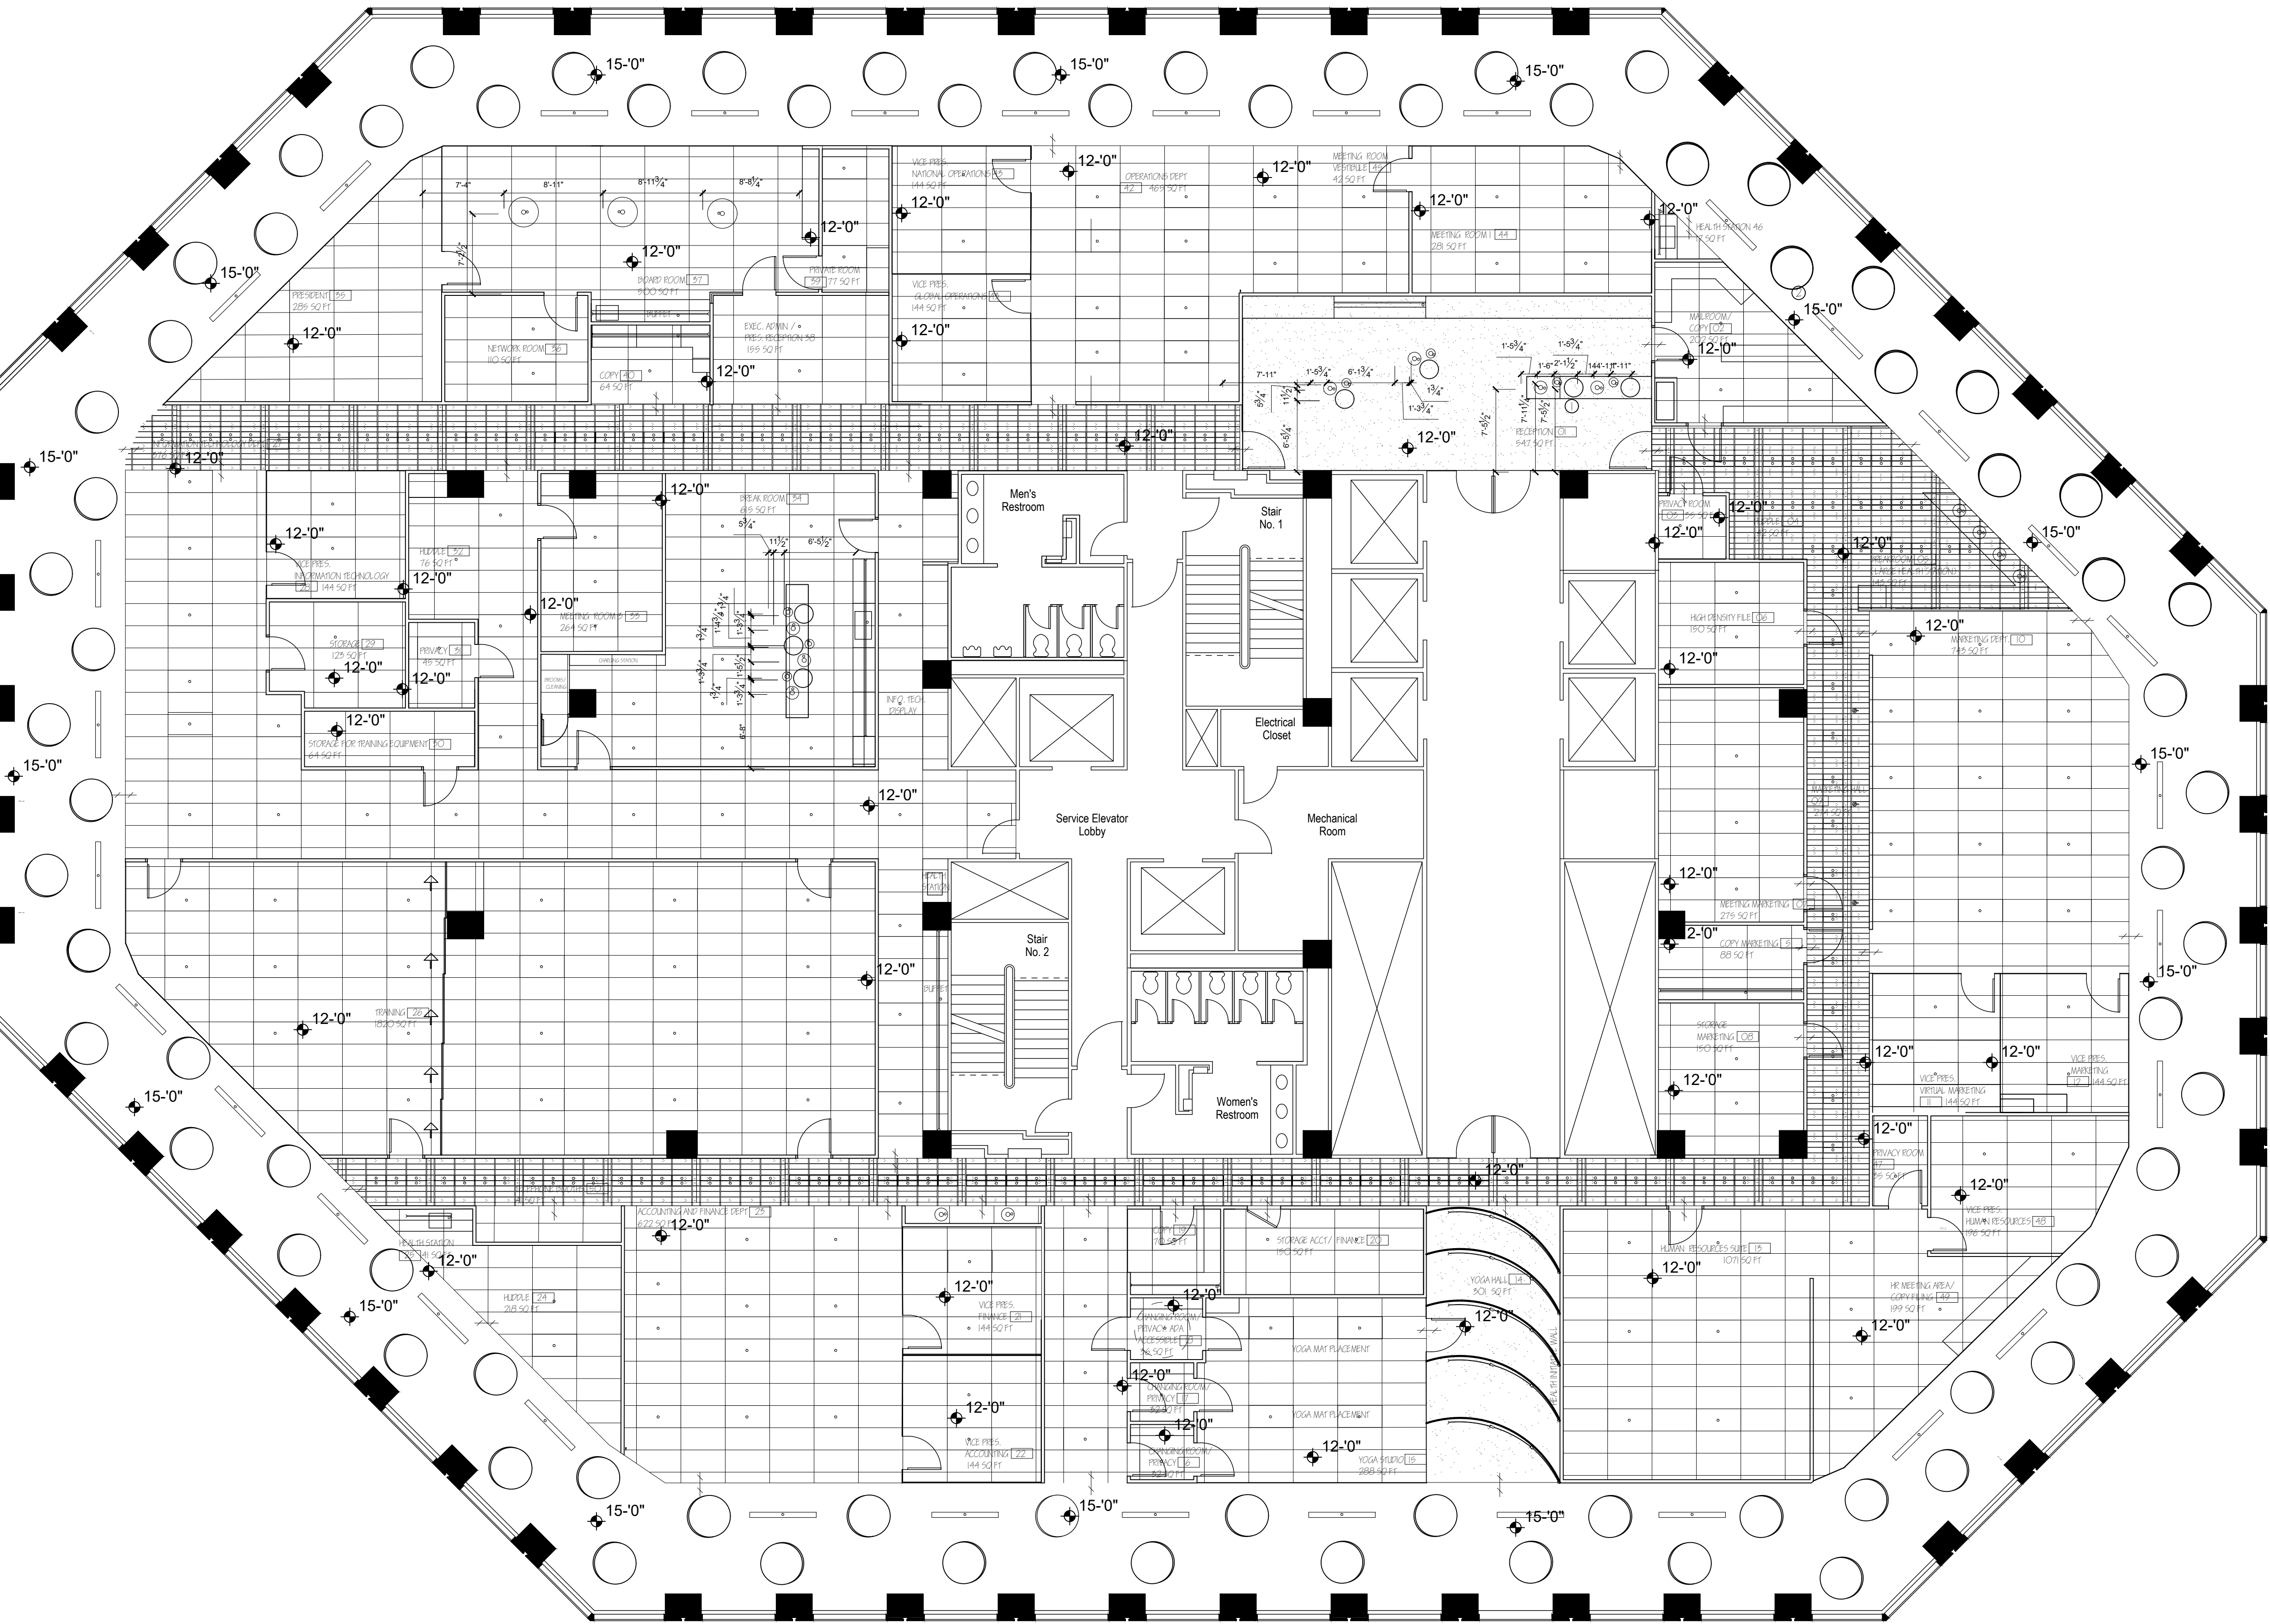

1 REFLECTED CEILING PLAN
SCALE: 1/8" = 1'-0"

- GENERAL NOTES:
1. ALL MILLWORK TO BE V.I.F.
 2. ALL DOORS ARE 3'-0" WIDTH
 3. ALL INTERIOR GLAZING IS 1/2" THICK
 4. ALL INTERIOR WALLS (GYPSUM BOARD) ARE 3.5" THICK.
 5. SEE NOTED ELEVATIONS FOR DETAILS
 6. ALL WALL OUTLETS TO BE MOUNTED AT 15" AFF EXCEPT WHERE LOCATED ABOVE COUNTERTOPS, THEN THEY SHALL BE 42" AFF. REFER TO ELEVATIONS FOR TYPICALS.
 7. ALL SWITCHES TO BE MOUNTED AT 36" AFF U.N.O.
 8. ALL LIGHTING FIXTURES ARE MEASURED TO THE CENTERLINE

- LOCAL NOTES:
1. LAYERED ACOUSTIC AND LIGHT PENDANT CONFIGURATION. REFER TO CEILING MATERIAL LEGEND AND LIGHTING LEGEND FOR DETAILS.
 2. ACOUSTIC CIRCLE SHAPED CIRCLE SUSPENDED FROM OPEN TO STRUCTURE AREA. REFER TO CEILING MATERIAL LEGEND. OPEN AREA IS FULL HEIGHT. ACOUSTIC CIRCLES TO BE SUSPENDED AT 12'-0" A.F.F. AS NOTED.

CEILING MATERIAL LEGEND

- GYPSUM BOARD
- OPEN TO STRUCTURE
- 2X4 ACOUSTIC CEILING TILE
- ARMSTRONG WOODWORKS LINEAR VENEERED PLANKS 24"X98" GRID SYSTEM
- CUSTOM ARCHED GYPSUM BOARD CEILING
- SLALOM TAILOR MADE CEILING MOUNT ACOUSTIC CIRCLE 47.2"D, MOUNTED AT 10' AFF
- SLALOM SPHERE FELT ACOUSTIC PANEL MED- 19.68"D

LIGHTING FIXTURE SCHEDULE

- TYPE 1- ARMSTRONG INTEGRATED LINEAR LIGHT FOR WOODWORKS SYSTEM
- TYPE 2- CREE INTEGRATED FLAT PANEL HIGH EFFICIENCY LIGHT FOR GRID SYSTEM
- TYPE 3- WAC 4.5" VOLTA LED DOWNLIGHT WALL WASHER
- TYPE 4- INTEGRATED UNDER CABINET LED LIGHTING- LIGHT STRIPS
- TYPE 5- INTEGRATED LED LIGHTING- LIGHT STRIPS
- TYPE 6- GRAY PANTS SCRAPLIGHTS SUN 32"D PENDANT
- TYPE 7- GRAY PANTS SCRAPLIGHTS MOON 14"D PENDANT
- TYPE 8- GRAY PANTS SCRAPLIGHTS MOON 10"D PENDANT
- TYPE 9- INTERLUX 150 LED LINEAR SUSPENDED PENDANT

F11B1 CORPORATE OFFICE
333 CLAY STREET SUITE 3700
HOUSTON TX 77002

PROJECT:

COMMERCIAL DESIGN

INDS 1345

REVISIONS

6		
5		
4		
3		
2		
1		

DATE: 01/23/2021

DRAFTED BY:

KALI STEELE

SHEET CONTENTS:

REFLECTED CEILING PLAN


SHEET:

1D-3

PRODUCED BY AN AUTODESK STUDENT VERSION

PRODUCED BY AN AUTODESK STUDENT VERSION

PRODUCED BY AN AUTODESK STUDENT VERSION

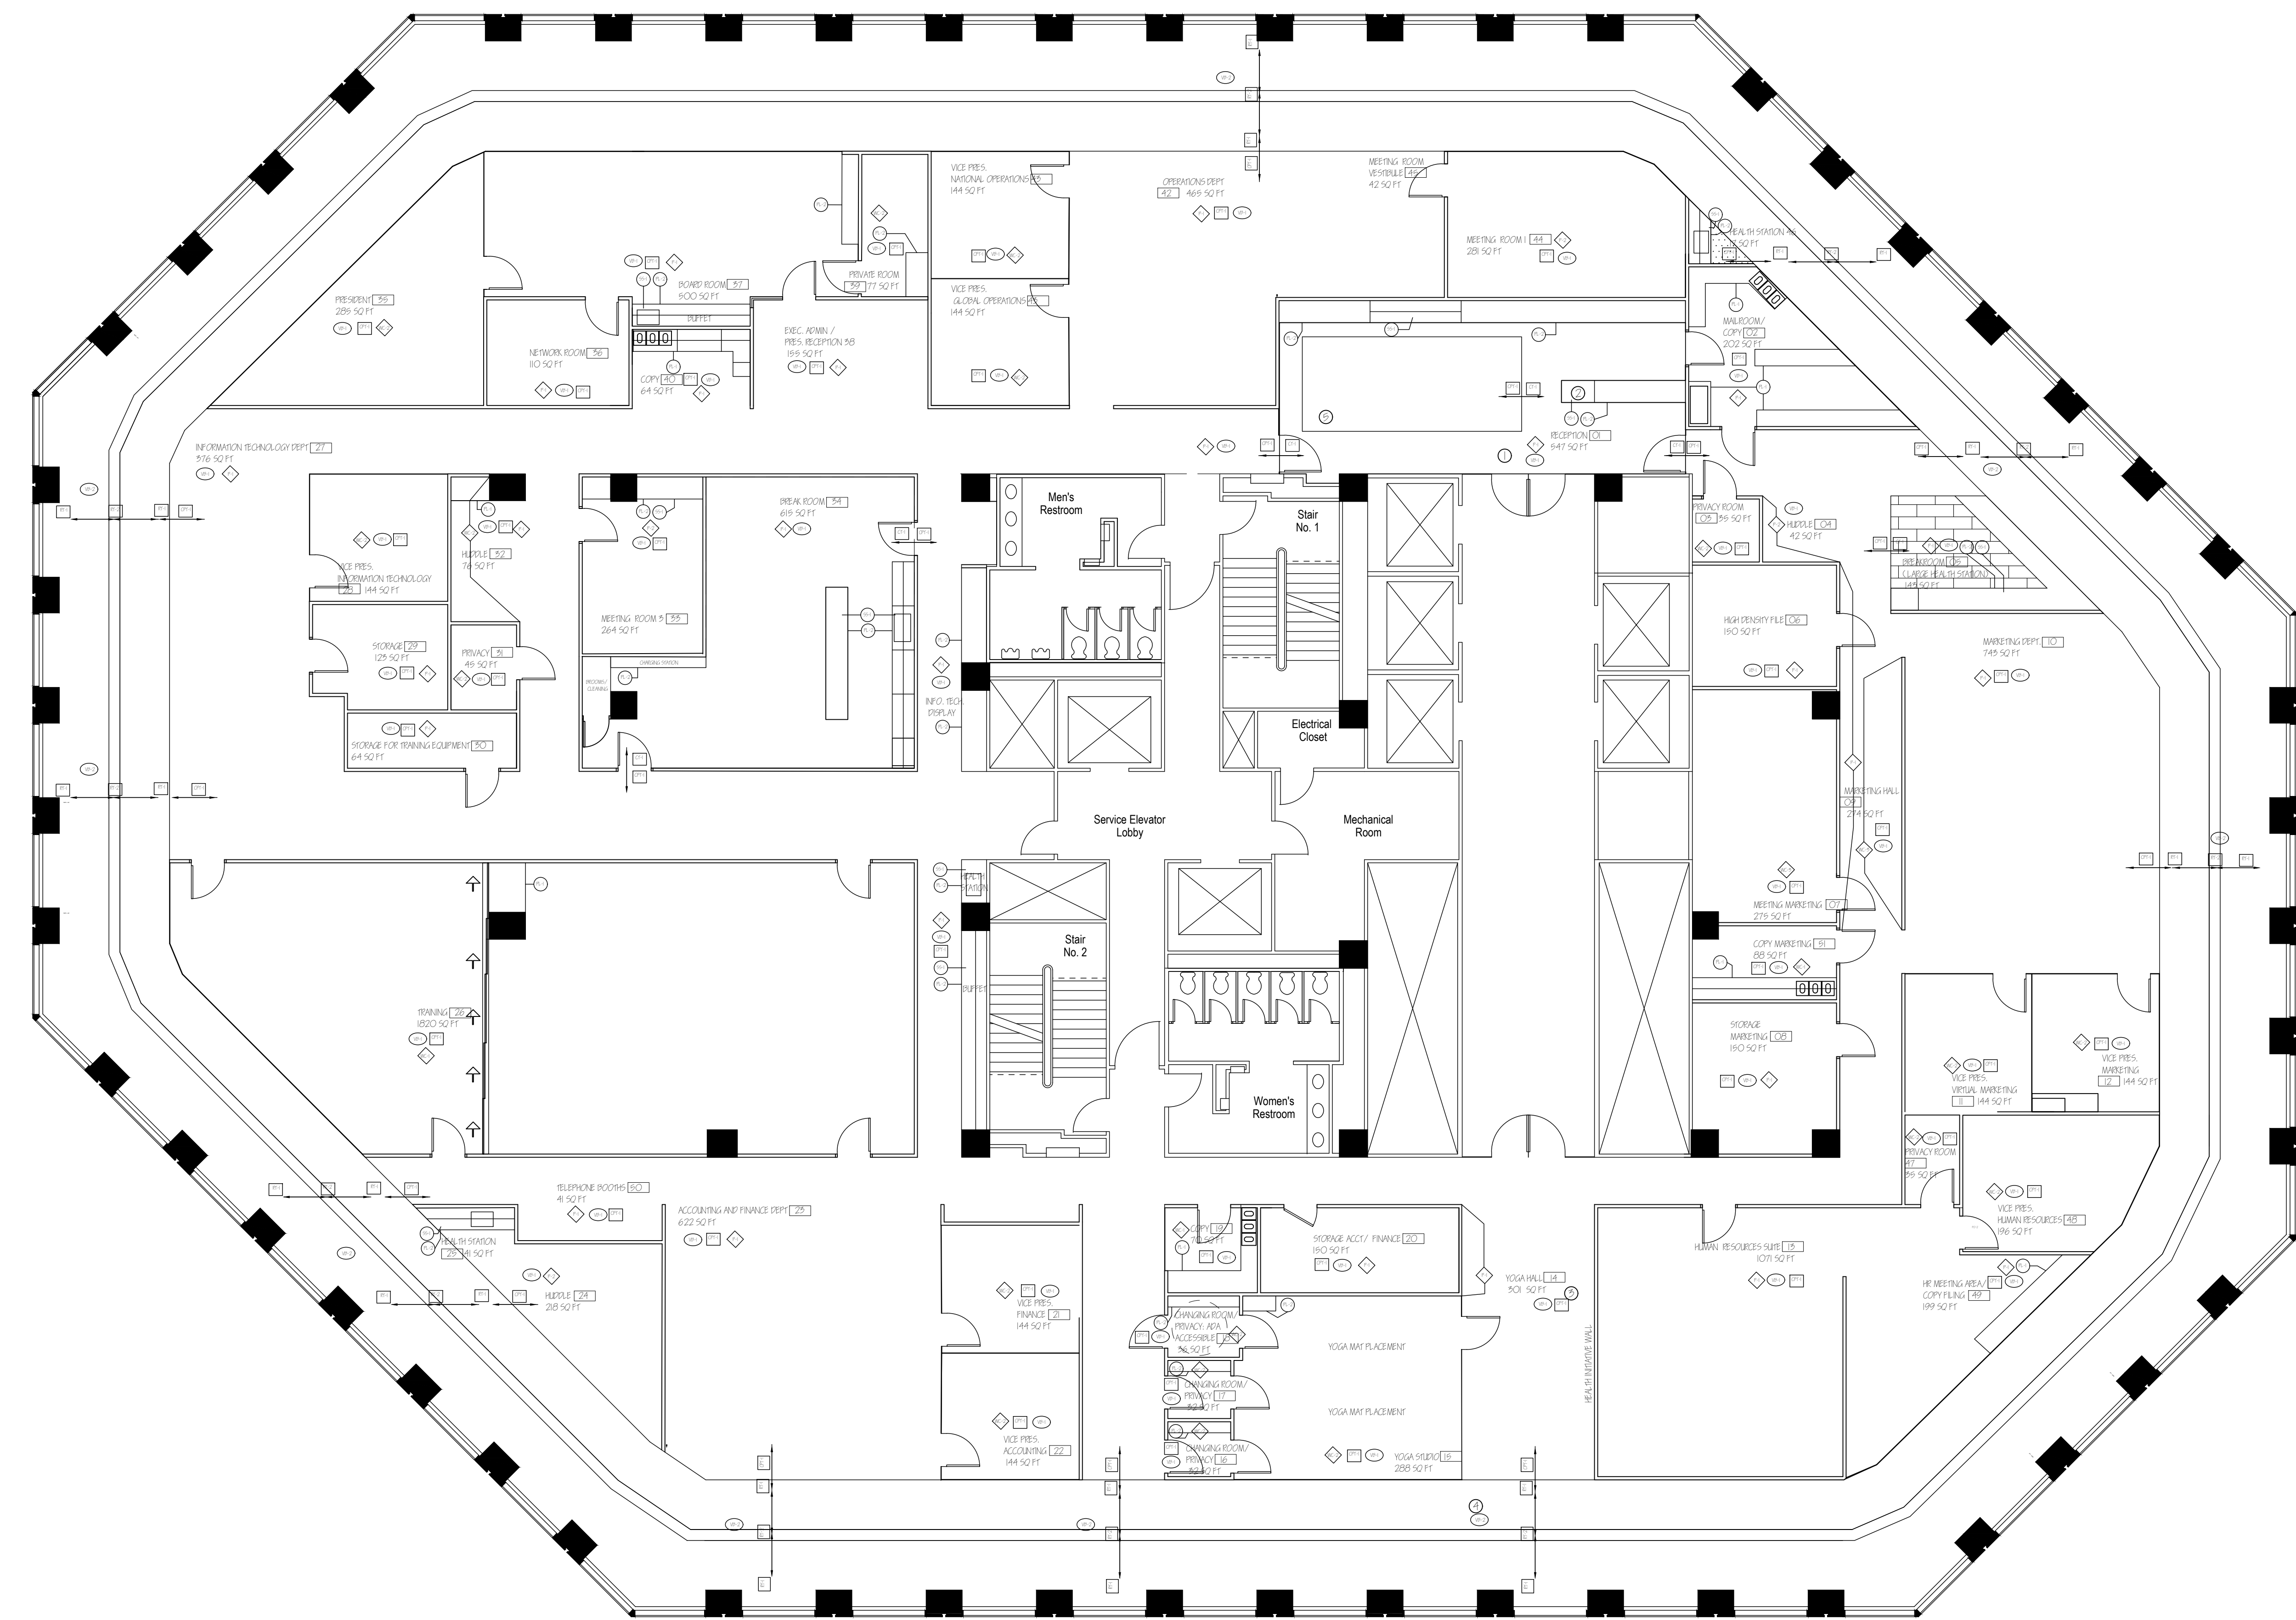


1 FINISH PLAN
SCALE: 1/8" = 1'-0"


- GENERAL NOTES:
1. ALL MILLWORK TO BE V.I.F.
 2. ALL DOORS ARE 3'-0" WIDTH
 3. ALL INTERIOR GLAZING IS 1/2" THICK
 4. ALL INTERIOR WALLS (GYPSUM BOARD) ARE 3/5" THICK.
 5. SEE NOTED ELEVATIONS FOR DETAILS
 6. ALL WALL OUTLETS TO BE MOUNTED AT 15" AFF. EXCEPT WHERE LOCATED ABOVE COUNTERTOPS, THEN THEY SHALL BE 42" AFF. REFER TO ELEVATIONS FOR TYPICALS.
 7. ALL SWITCHES TO BE MOUNTED AT 36" AFF U.N.O.

- LOCAL NOTES:
1. REFER TO SHEET A.5 FOR FINISH SCHEDULE
 2. CUSTOM RECEPTION DESK HAS A MIX OF MATERIALS. REFER TO ELEVATION.
 3. FOR YOGA HALL, SEE RCP FOR WALL FINISH
 4. AS DRAWN, RUBBER TILE EXTERIOR RACETRACK WILL BE DIVIDED AS SHOWN WITH RT-2 LINED ON EITHER SIDE BY RT-1
 5. CARPET INSET INTO TILE


FLOORING FINISHES:

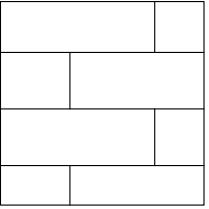

CT-1 : CERAMIC TILE

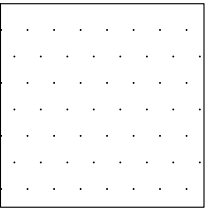

CPT-1 : CARPET

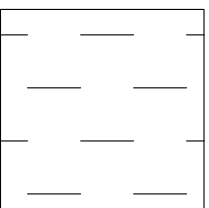

RT-1 AND RT-2: RUBBER TILE



MATERIAL TRANSITION



PROJECT:
FIBIT CORPORATE OFFICE
333 CLAY STREET SUITE 3700
HOUSTON TX 77002

COMMERCIAL DESIGN
INDS 1345

REVISIONS

6		
5		
4		
3		
2		
1		

DATE: 01/23/2021
DRAFTED BY:
KALI STEELE

SHEET CONTENTS:
FINISH PLAN

SHEET:
ID-4

PRODUCED BY AN AUTODESK STUDENT VERSION

PRODUCED BY AN AUTODESK STUDENT VERSION

PRODUCED BY AN AUTODESK STUDENT VERSION

PRODUCED BY AN AUTODESK STUDENT VERSION



PROJECT:
F11B1T CORPORATE OFFICE
333 CLAY STREET SUITE 3700
HOUSTON TX 77002

COMMERCIAL DESIGN

INDS 1345

REVISIONS


6		
5		
4		
3		
2		
1		

DATE: 01/23/2021

DRAFTED BY:
KALI STEELE

SHEET CONTENTS:
FINISH SCHEDULE

SHEET:
1D-5

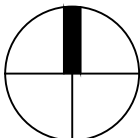


FINISH SYMBOLS



CARPET 1



VINYL WALLBASE 1

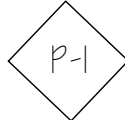

PAINT 1



PORCELAIN TILE 1



VINYL WALLBASE 2



PAINT 2



RUBBER TILE 1



WALL COVERING 1



SOLID SURFACE 1



RUBBER TILE 2



WALL COVERING 2




PLASTIC LAMINATE 1




WALL COVERING 3



PLASTIC LAMINATE 2

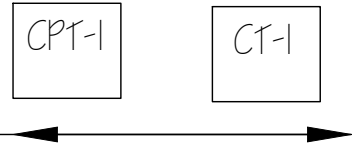

FLOOR TRANSITION MARKER

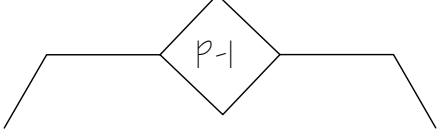

WALL FINISHES INDICATOR

FINISH SCHEDULE

CARPET

CPT-1 Manufacturer	Mannington Commercial
Style Name	Serikos II
Style Number	n/a
Style Color	Magnolia 85144
Construction	Enhanced Textured Loop
Size	12' width
Content	Hollow Filament Nylon
Installation	Up the Roll

VINYL WALL BASE

VB-1 Manufacturer	Tarkett
Collection	Tightlock
Profile	Carpet
Product Number	440556123
Color	Tidewater
Color Number	192
Size	3 1/4"

VB-2 Manufacturer	Tarkett
Collection	Tightlock
Profile	Resilient
Product Number	440556123
Color	Beige
Color Number	49
Size	3 1/4"

PAINT

P-1 Manufacturer	Sherwin Williams
Color Name	Origami White
Color Number	7636
Finish	Matte

P-2 Manufacturer	Sherwin Williams
Color Name	Cavern Clay
Color Number	7701
Finish	Matte

CERAMIC TILE

CT-1 Manufacturer	Dal-Tile
Product Name	Portfolio
Product Number	PF10
Product Color	Cotto 10
Size	12"x24"
Grout	Mapei FlexColor CQ Grout
Grout Color	Pecan 112
Installation	Straight
Slip Resistance	StepWise System

WALLCOVERING

WC-1 Manufacturer	Arc-Com
Collection	Vinyl- Type II
Style Name	Benwick
Style Number	ACW-52708
Style Color	Frosted Pearl #1
Width	54"
Repeat	Random Match
Hang	Reverse Hung
Backing	Recycled Woven Polycotton Osnaburg

WC-2 Manufacturer	Koroseal
Collection	n/a
Style Name	Canopy
Style Number	CL02
Style Color	Dapple 03
Width	52-54"
Repeat	Vertical: 33"; Horizontal: 52"
Hang	Non-Reverse Hang; Straight Match
Backing	Non-Woven

SOLID SURFACE

SS-1 Manufacturer	Dekton by Costentino
Color Name	Entzo
Color Number	n/a
Thickness	2 cm
Finish	Matte
Edge Profile	Mitred Edge
Format	320 x 144 cm
Species	Blend of quartz, porcelain, and glass

RUBBER TILE


RT-1 Manufacturer	Mannington Commercial
Collection	Color Anchor Collection
Product Name	Colorscape
Product Number	n/a
Product Color	Sandy Tan 112
Size	36" x 36"
Construction Type	Homogeneous Thermoset Rubber Tile
Profile	Smooth
Classification	Class I, Type A
Finish	Matte

PLASTIC LAMINATE

PL-1 Manufacturer	Wilsonart
Color Name	Avondale Ash
Color Number	8228
Finish	38 Fine Velvet Texture

PL-2 Manufacturer	Wilsonart
Color Name	Blond Echo
Color Number	7939
Finish	38 Fine Velvet Texture

PRODUCED BY AN AUTODESK STUDENT VERSION

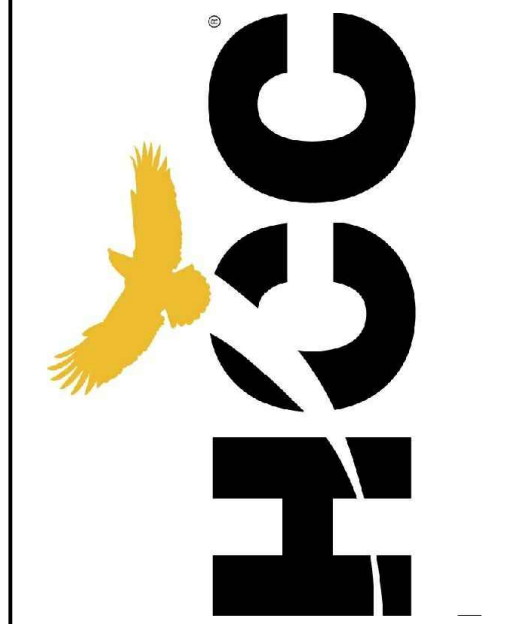

PROJECT:
FITBIT CORPORATE OFFICE
333 CLAY STREET SUITE 3700
HOUSTON TX 77002

COMMERCIAL DESIGN
INDS 1345

REVISIONS		
6		
5		
4		
3		
2		
1		

DATE: 01/23/2021

DRAFTED BY:
KALI STEELE

SHEET CONTENTS:
ELEVATIONS
AND DETAILS


SHEET:
ID-6

GENERAL NOTES:


1. ALL MILLWORK TO BE V.I.F.
2. ALL DOORS ARE 3'-0" WIDTH
3. ALL INTERIOR GLAZING IS 1/2" THICK
4. ALL INTERIOR WALLS (GYPSUM BOARD) ARE 3.5" THICK.
5. SEE NOTED ELEVATIONS FOR DETAILS
6. ALL WALL OUTLETS TO BE MOUNTED AT 1" AFF U.N.O
7. ALL SWITCHES TO BE MOUNTED AT 1" AFF U.N.O.

LOCAL NOTES:


1. SEE FINISH PLAN FOR FLOORING AND MORE OVERALL FINISH PLACEMENT.

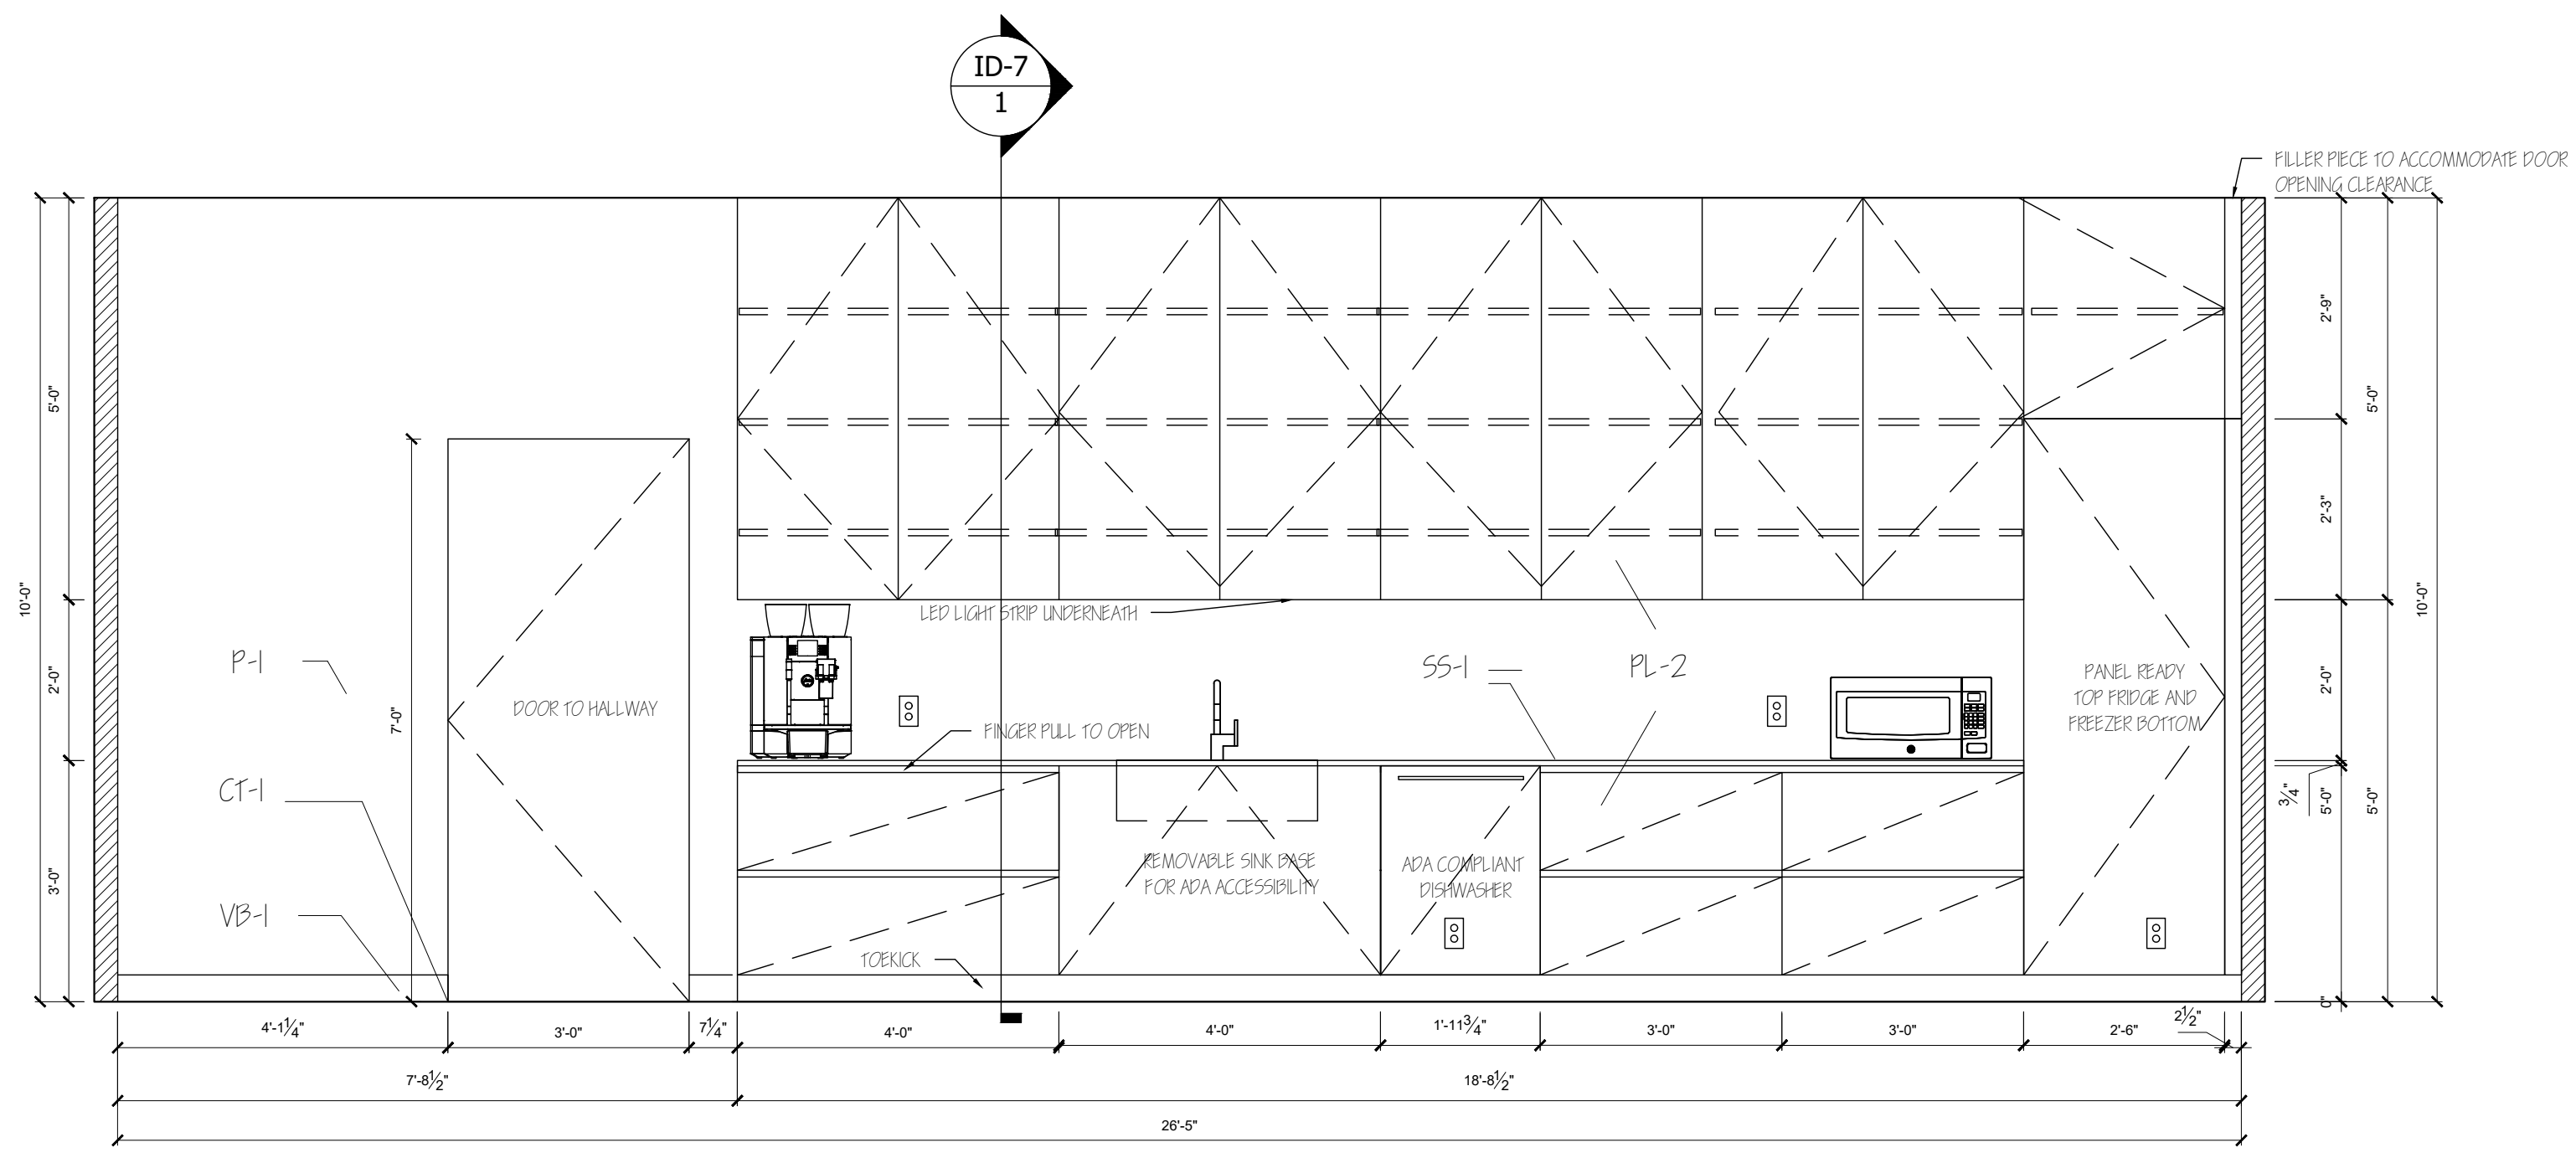


4 BREAK ROOM I #30 ELEVATION
SCALE: 1/2" = 1'-0"

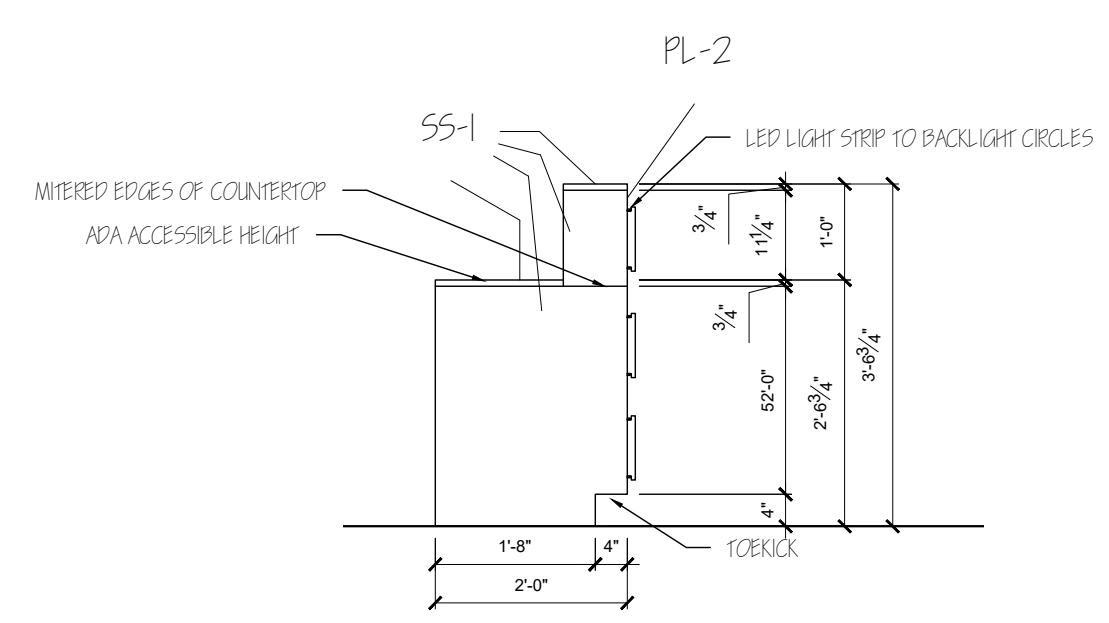


3 RECEPTION DESK #1 SIDE ELEVATION
SCALE: 1/2" = 1'-0"

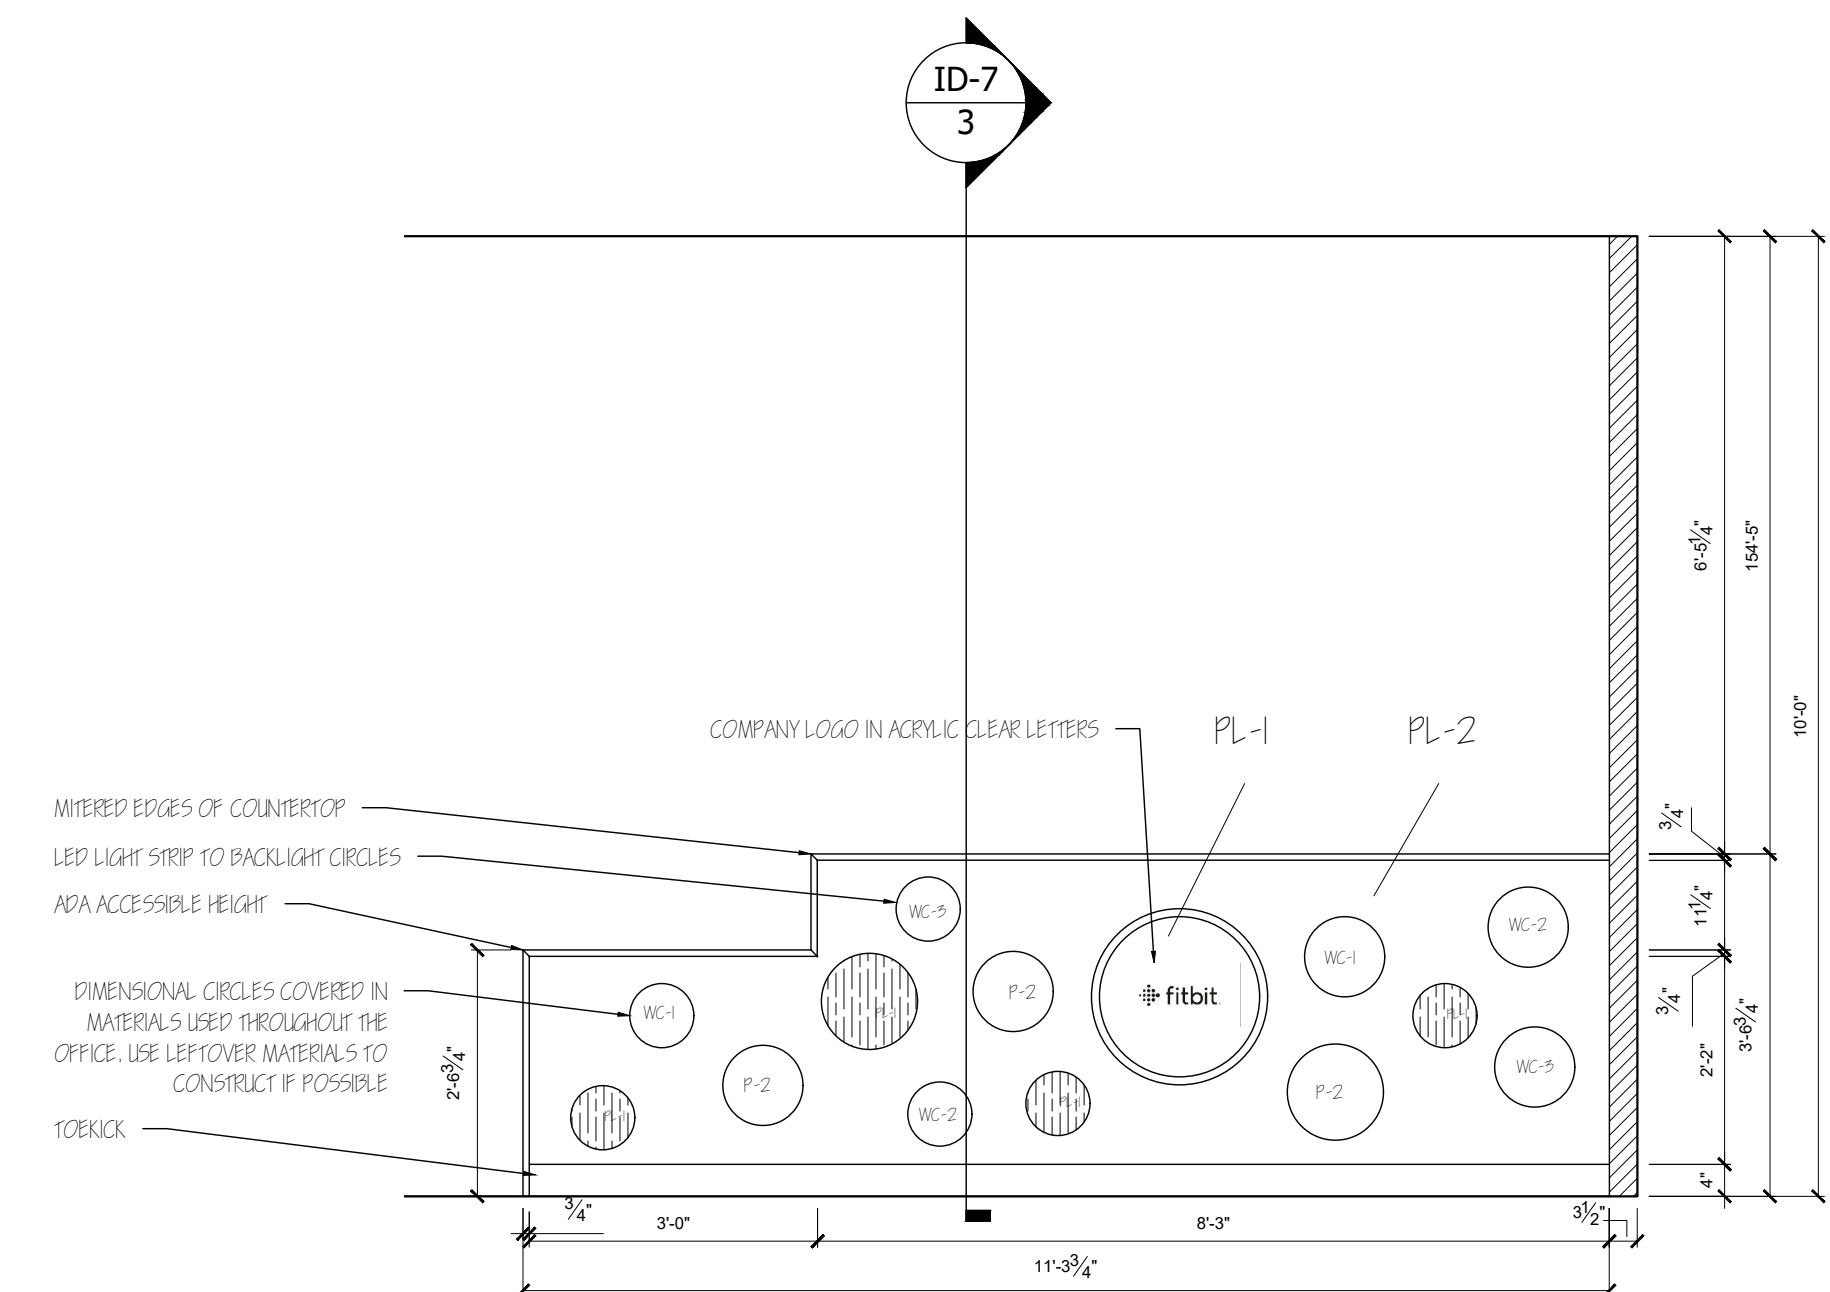

2 RECEPTION DESK #1 ELEVATION
SCALE: 1/2" = 1'-0"

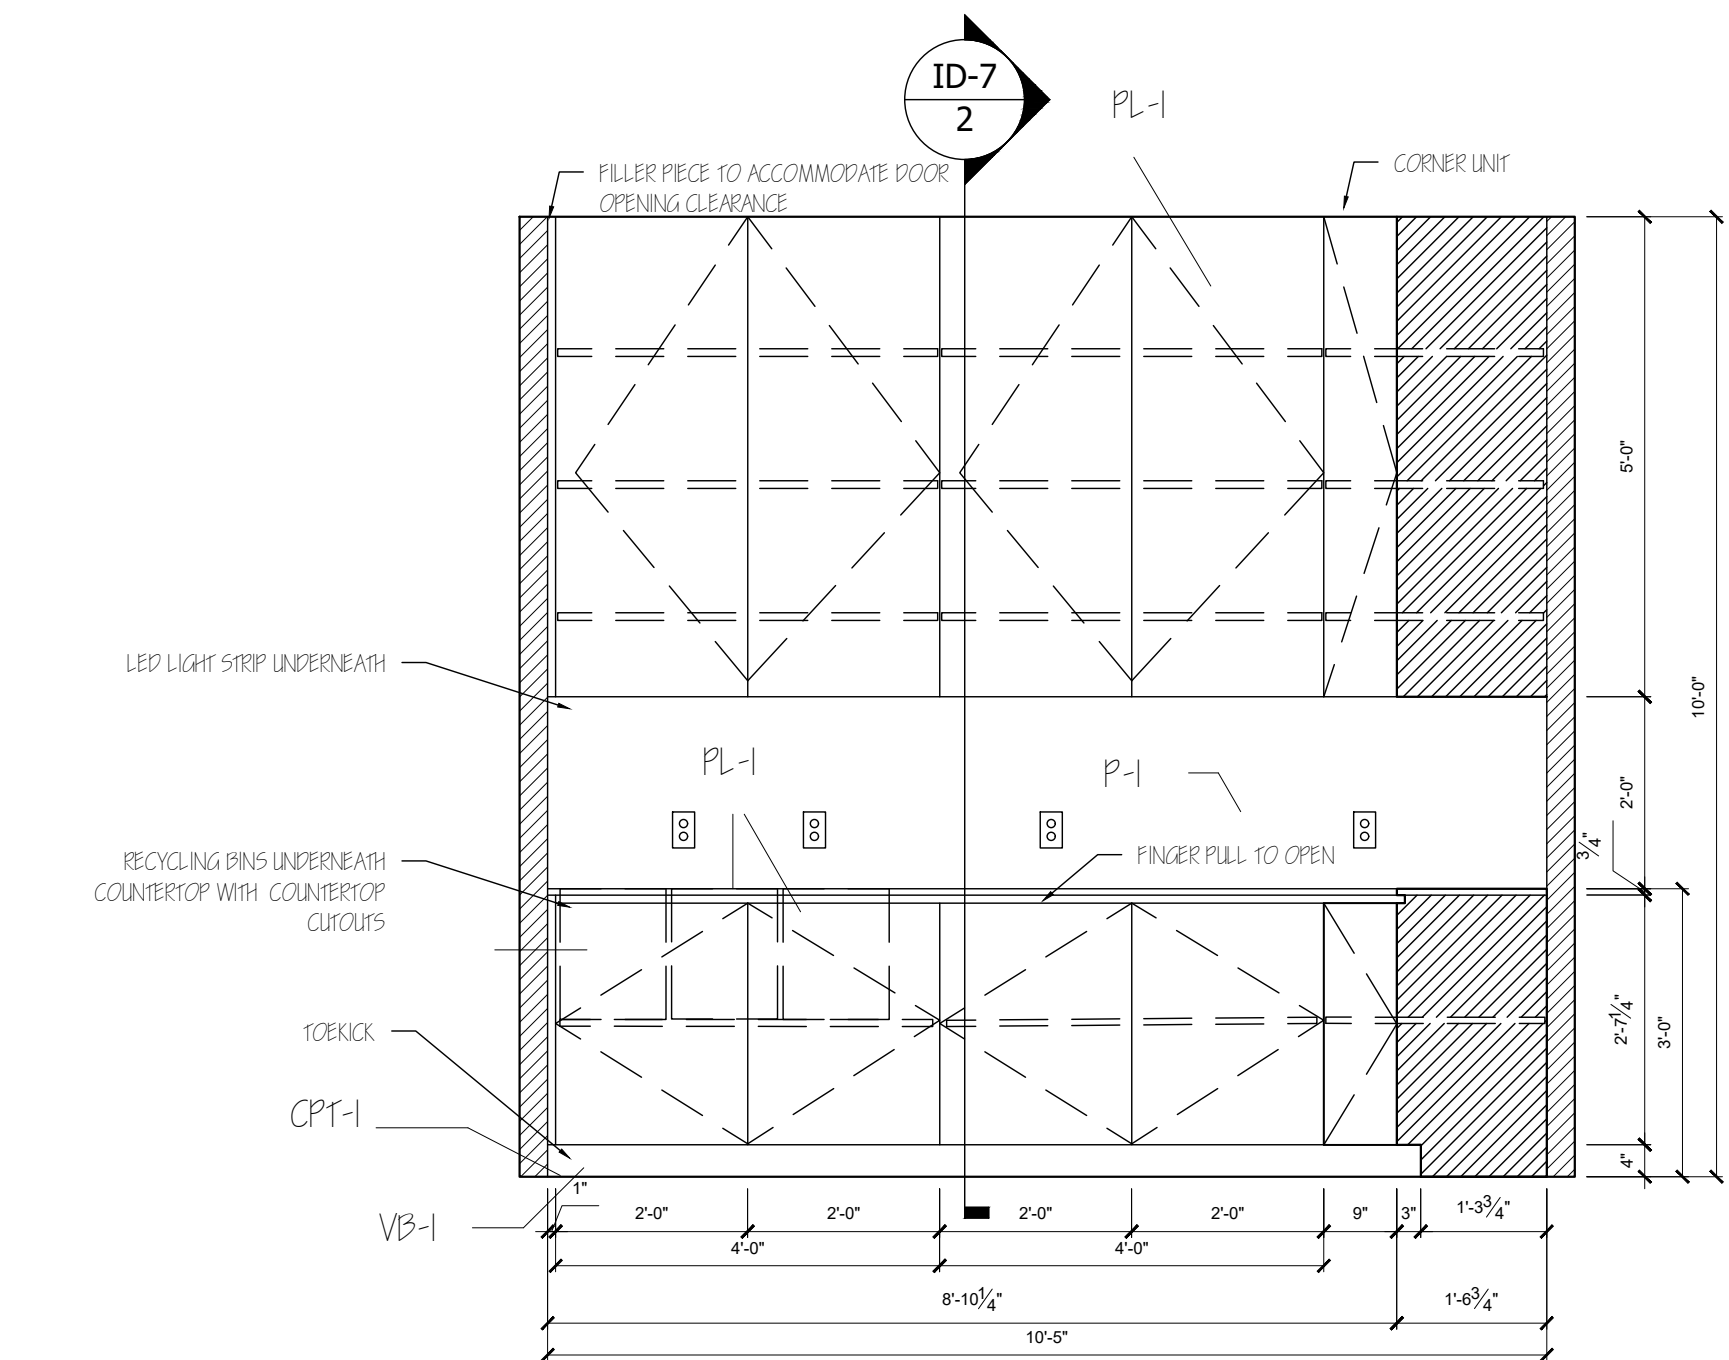

5 COPY ROOM #40 ELEVATION
SCALE: 1/2" = 1'-0"

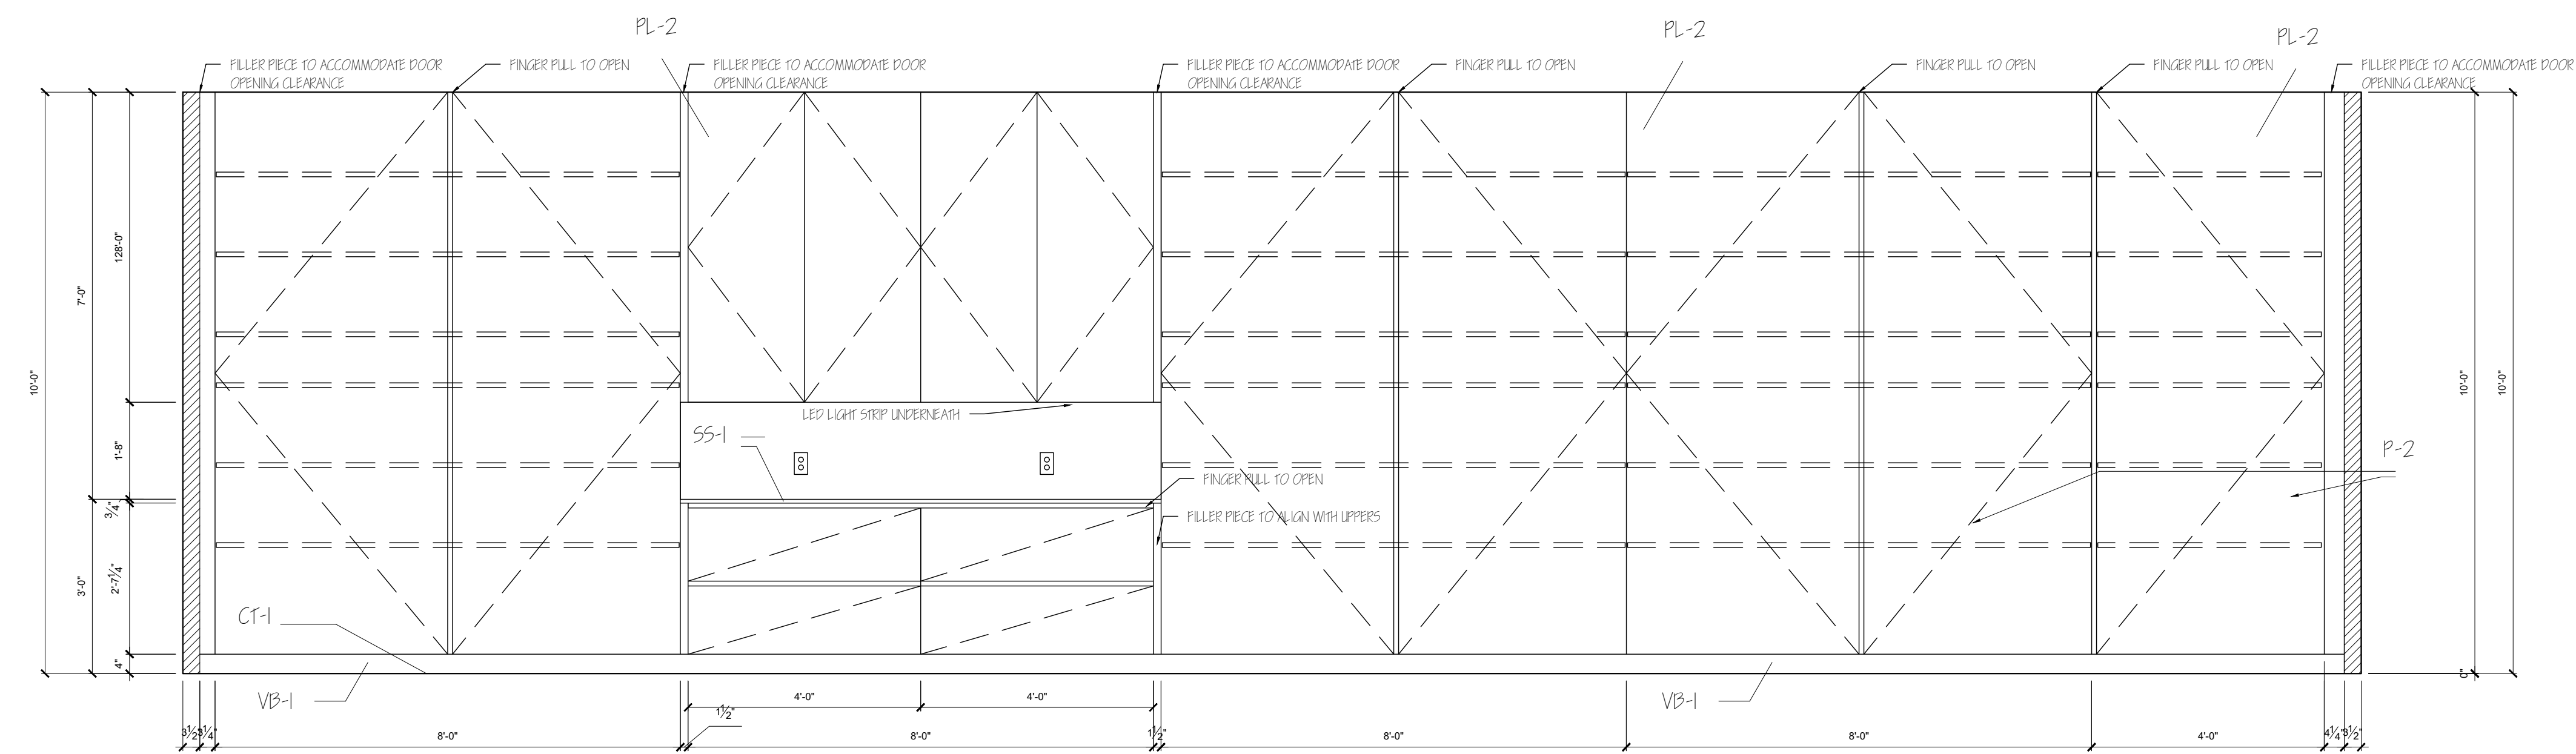

1 RECEPTION ROOM #1 ELEVATION
SCALE: 1/2" = 1'-0"



PROJECT:
FIBIT CORPORATE OFFICE
333 CLAY STREET SUITE 3700
HOUSTON TX 77002

COMMERCIAL DESIGN
INDS 1345

REVISIONS		
6		
5		
4		
3		
2		
1		

DATE: 01/23/2021


DRAFTED BY:
KALI STEELE

SHEET CONTENTS:
DETAILS


SHEET:
ID-7

- GENERAL NOTES:
- ALL MILLWORK TO BE V.I.F.
 - ALL DOORS ARE 3'-0" WIDTH
 - ALL INTERIOR GLAZING IS $\frac{1}{2}$ " THICK
 - ALL INTERIOR WALLS (GYPSUM BOARD) ARE 3.5" THICK.
 - SEE NOTED ELEVATIONS FOR DETAILS
 - ALL WALL OUTLETS TO BE MOUNTED AT 1" AFF U.N.O
 - ALL SWITCHES TO BE MOUNTED AT 1" AFF U.N.O.


- LOCAL NOTES:
- SEE FINISH PLAN AND SCHEDULE FOR MORE INFORMATION

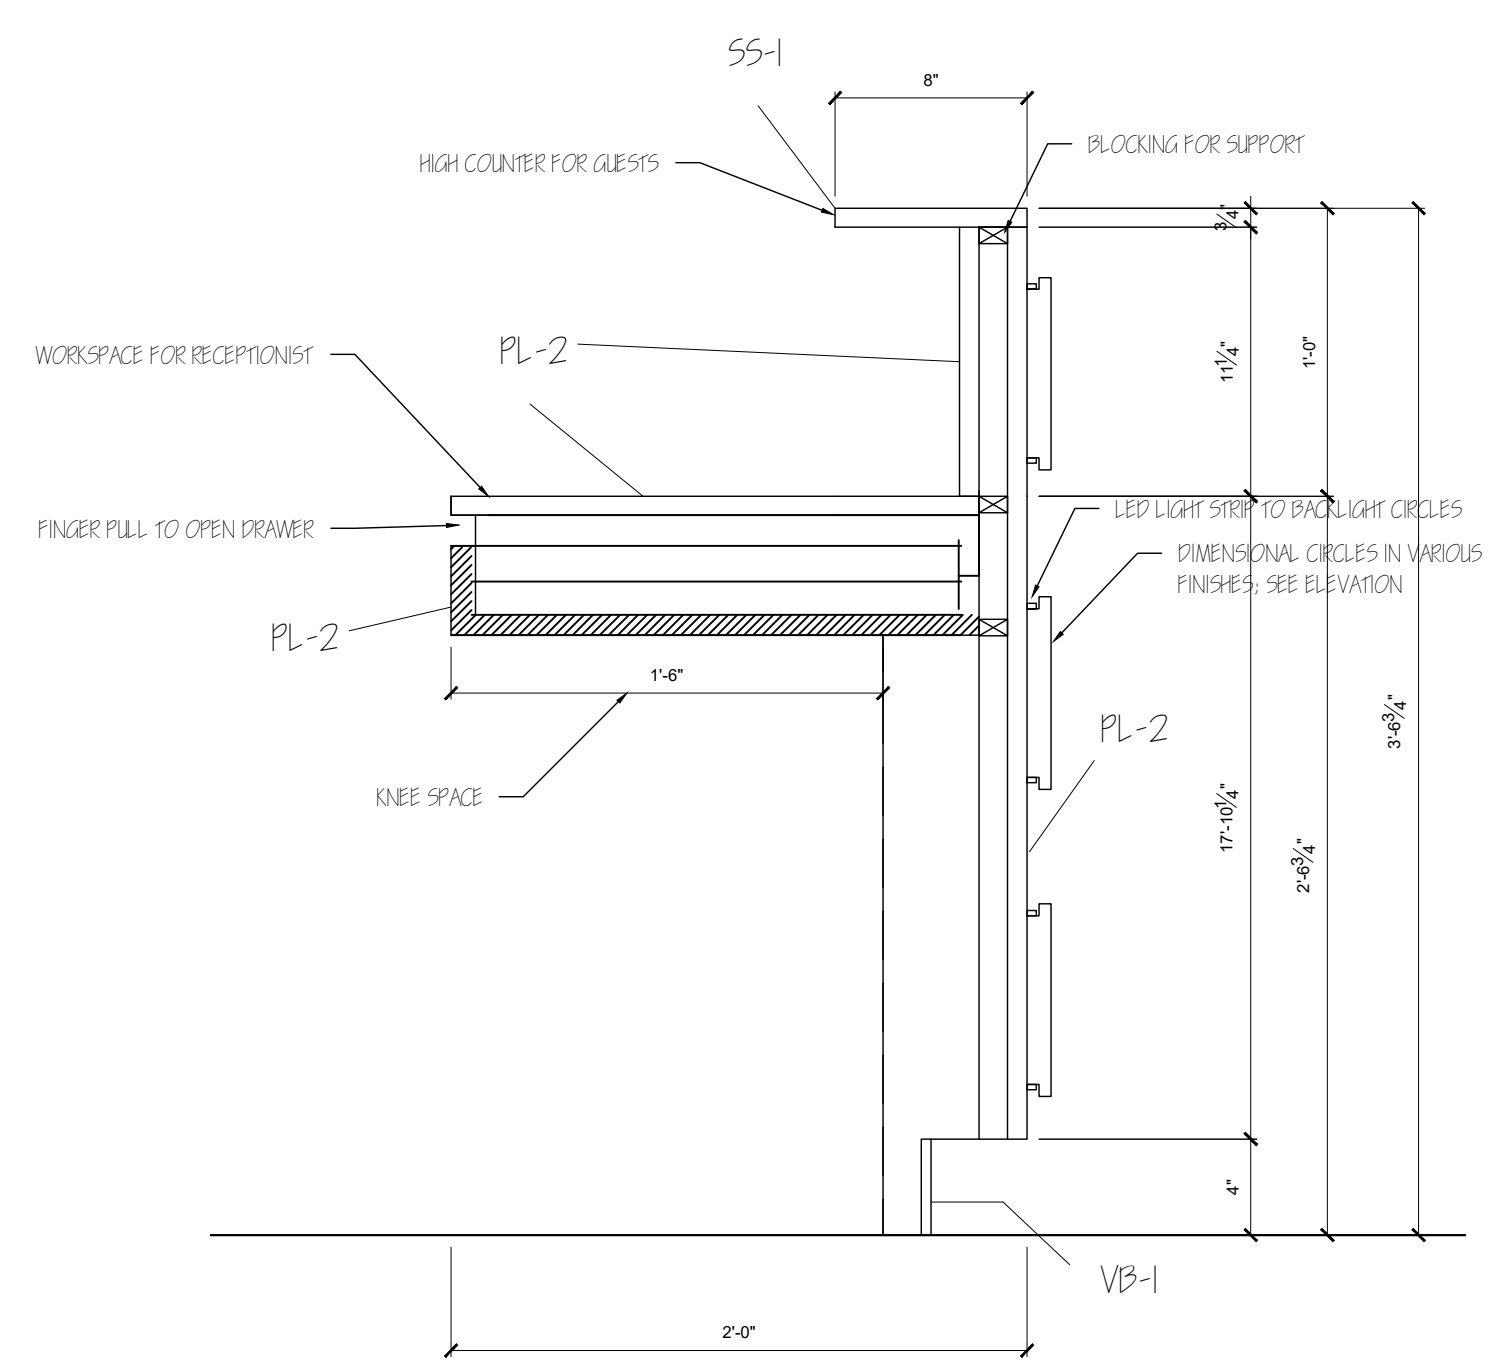


3 RECEPTION DESK MILLWORK DETAIL
SCALE: $\frac{1}{2}$ " = 1'-0"

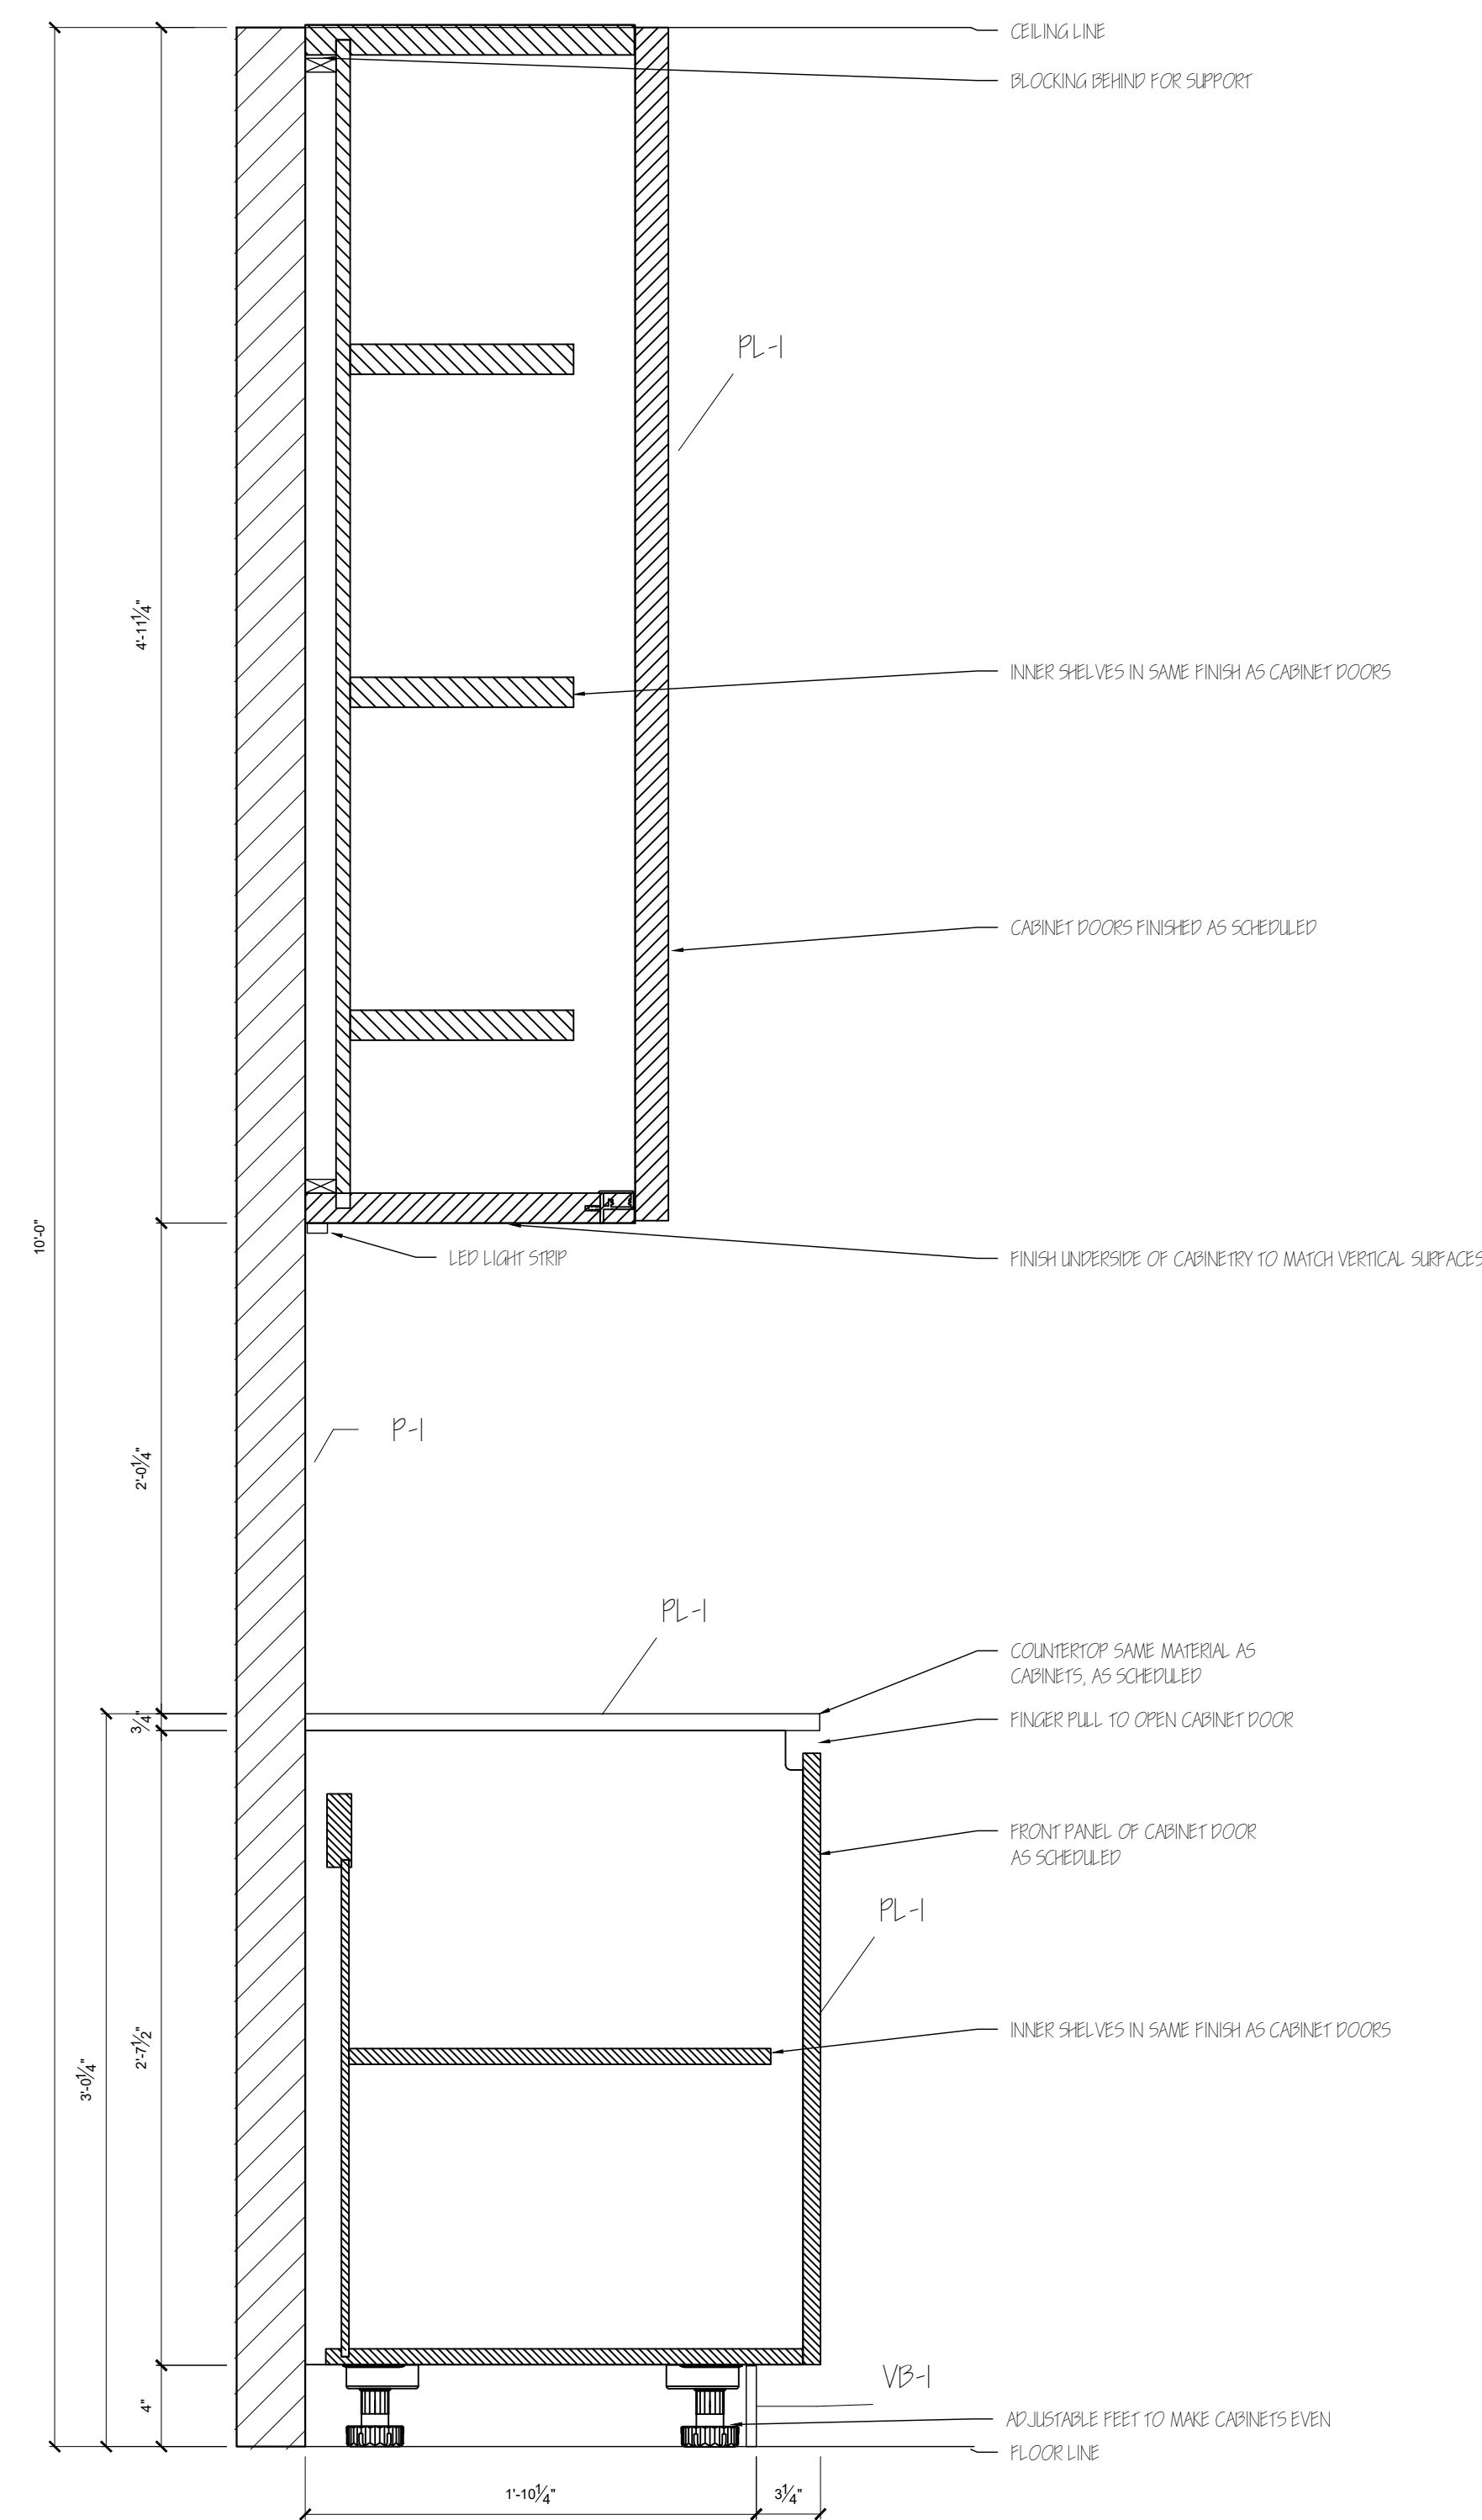

2 COPY ROOM MILLWORK DETAIL - TYPICAL
SCALE: $\frac{1}{2}$ " = 1'-0"

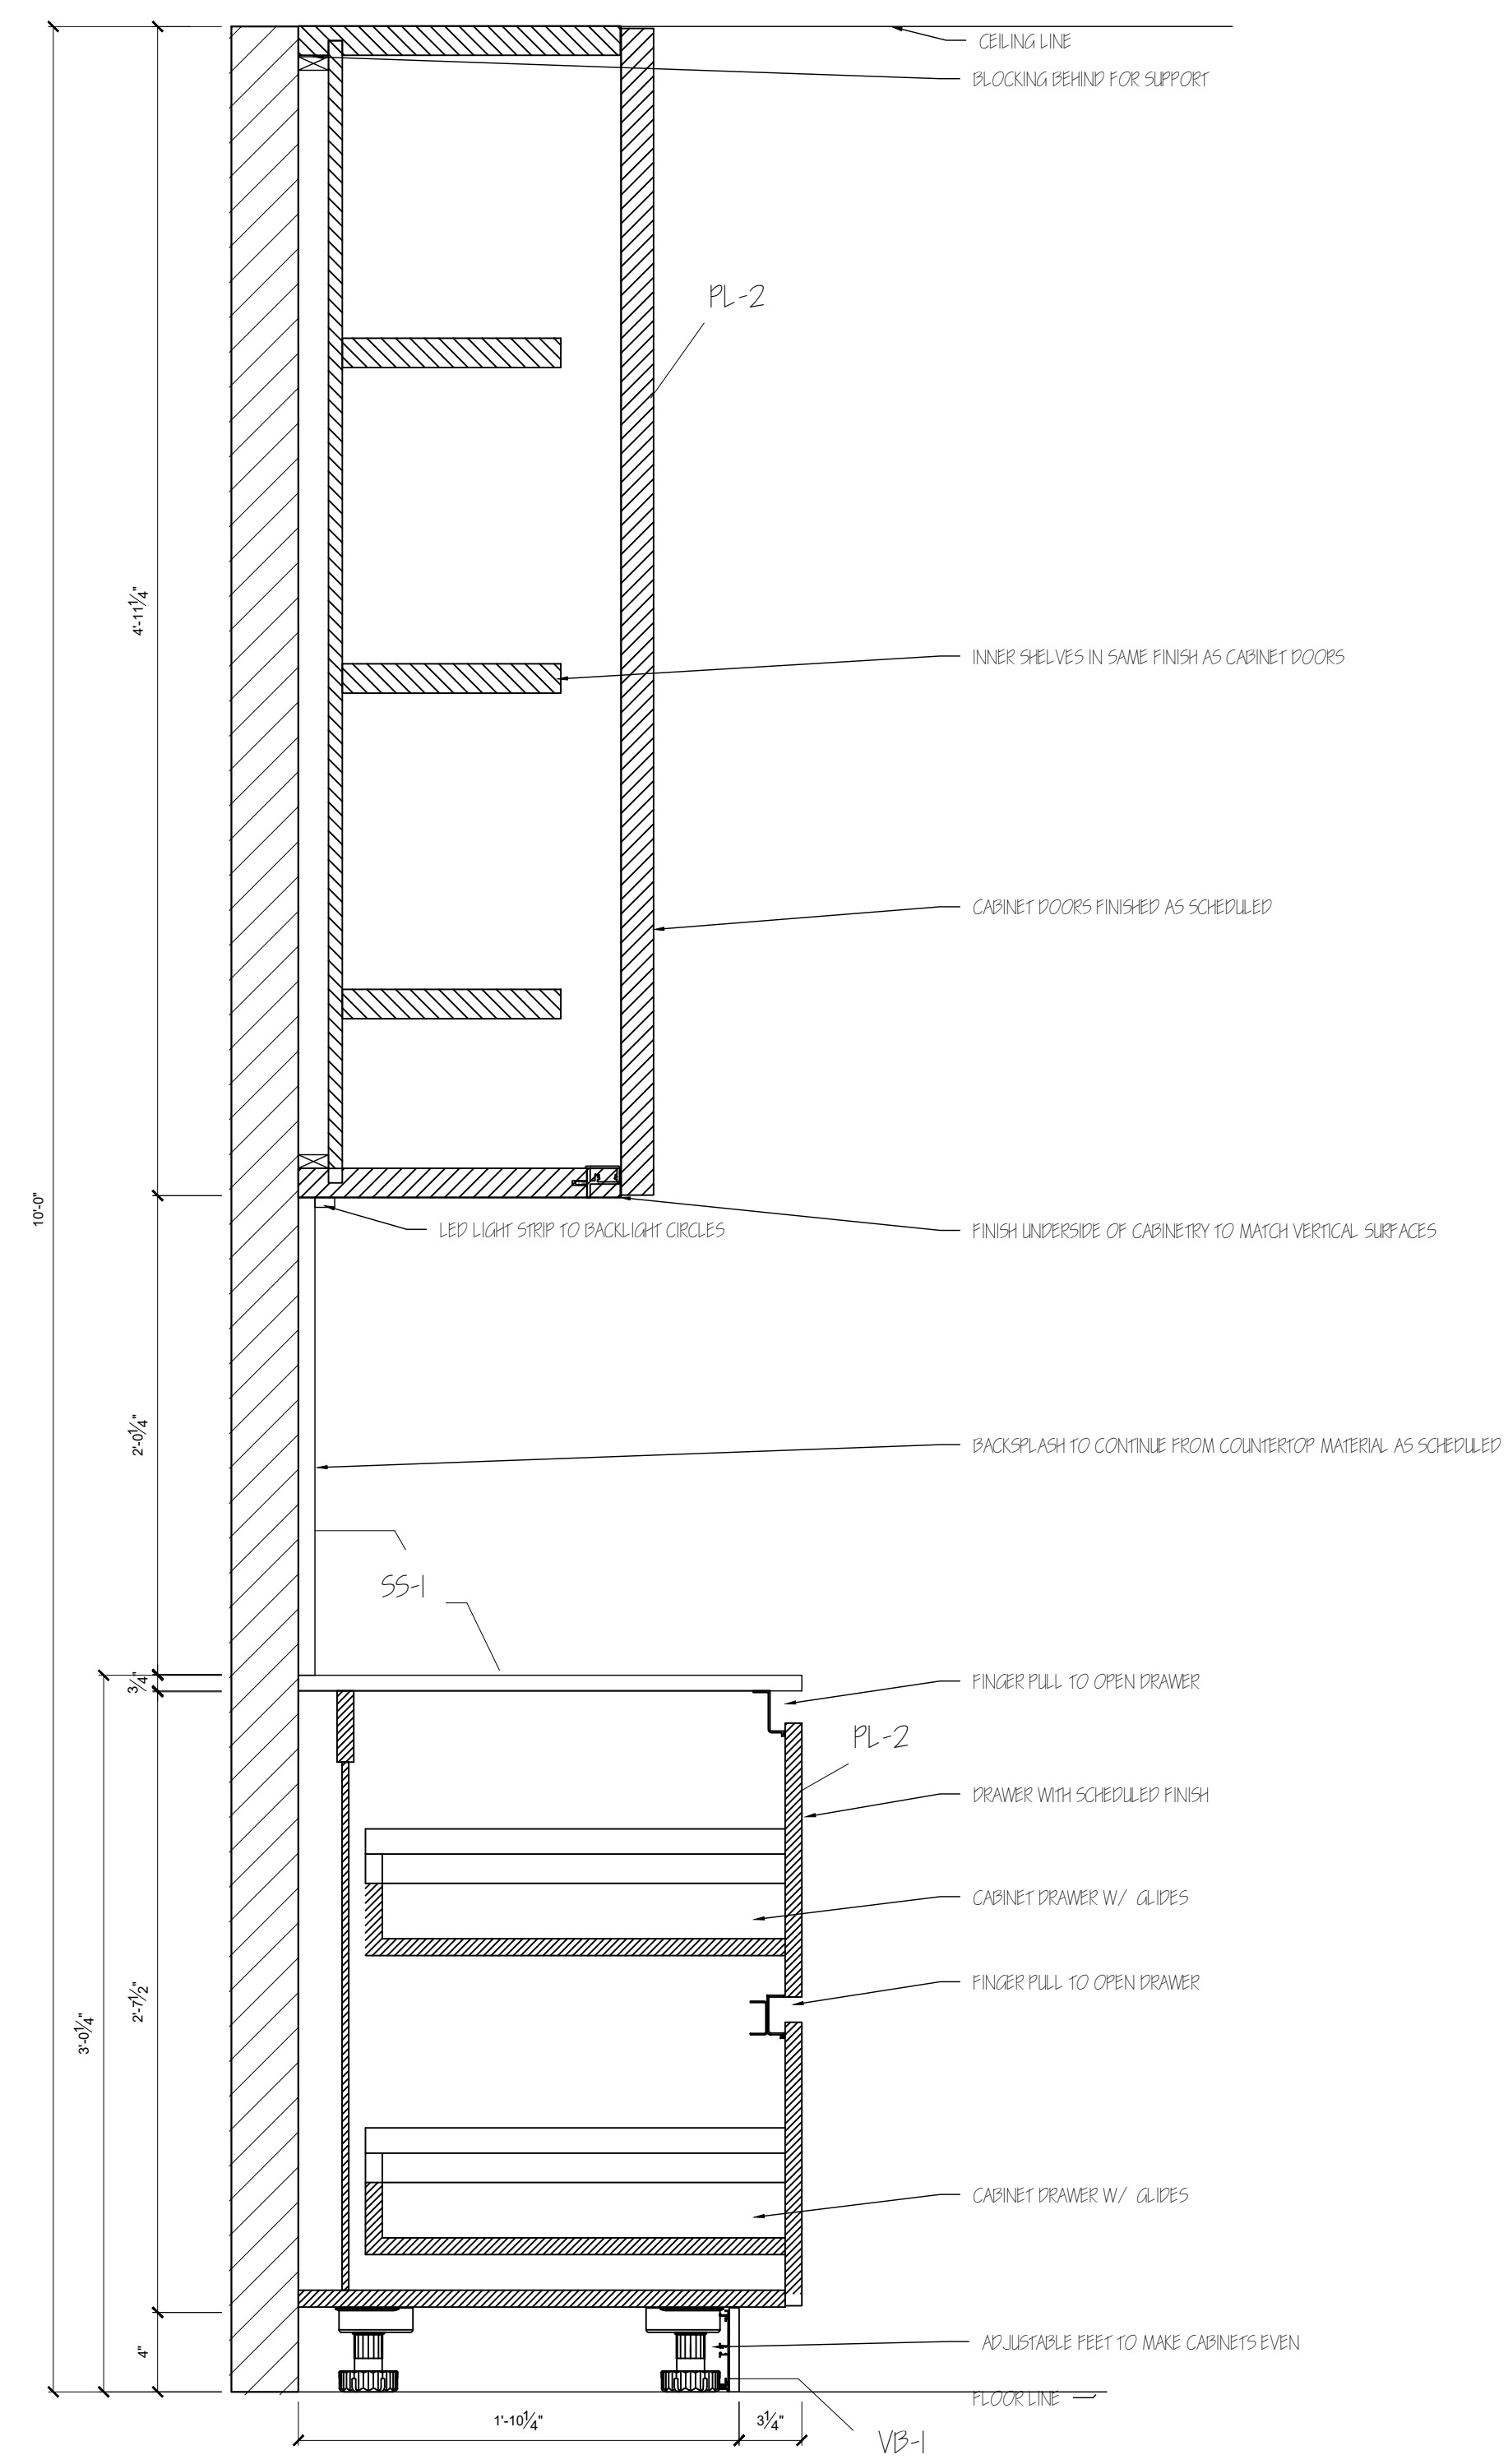

1 BREAK ROOM I MILLWORK DETAIL
SCALE: $\frac{1}{2}$ " = 1'-0"

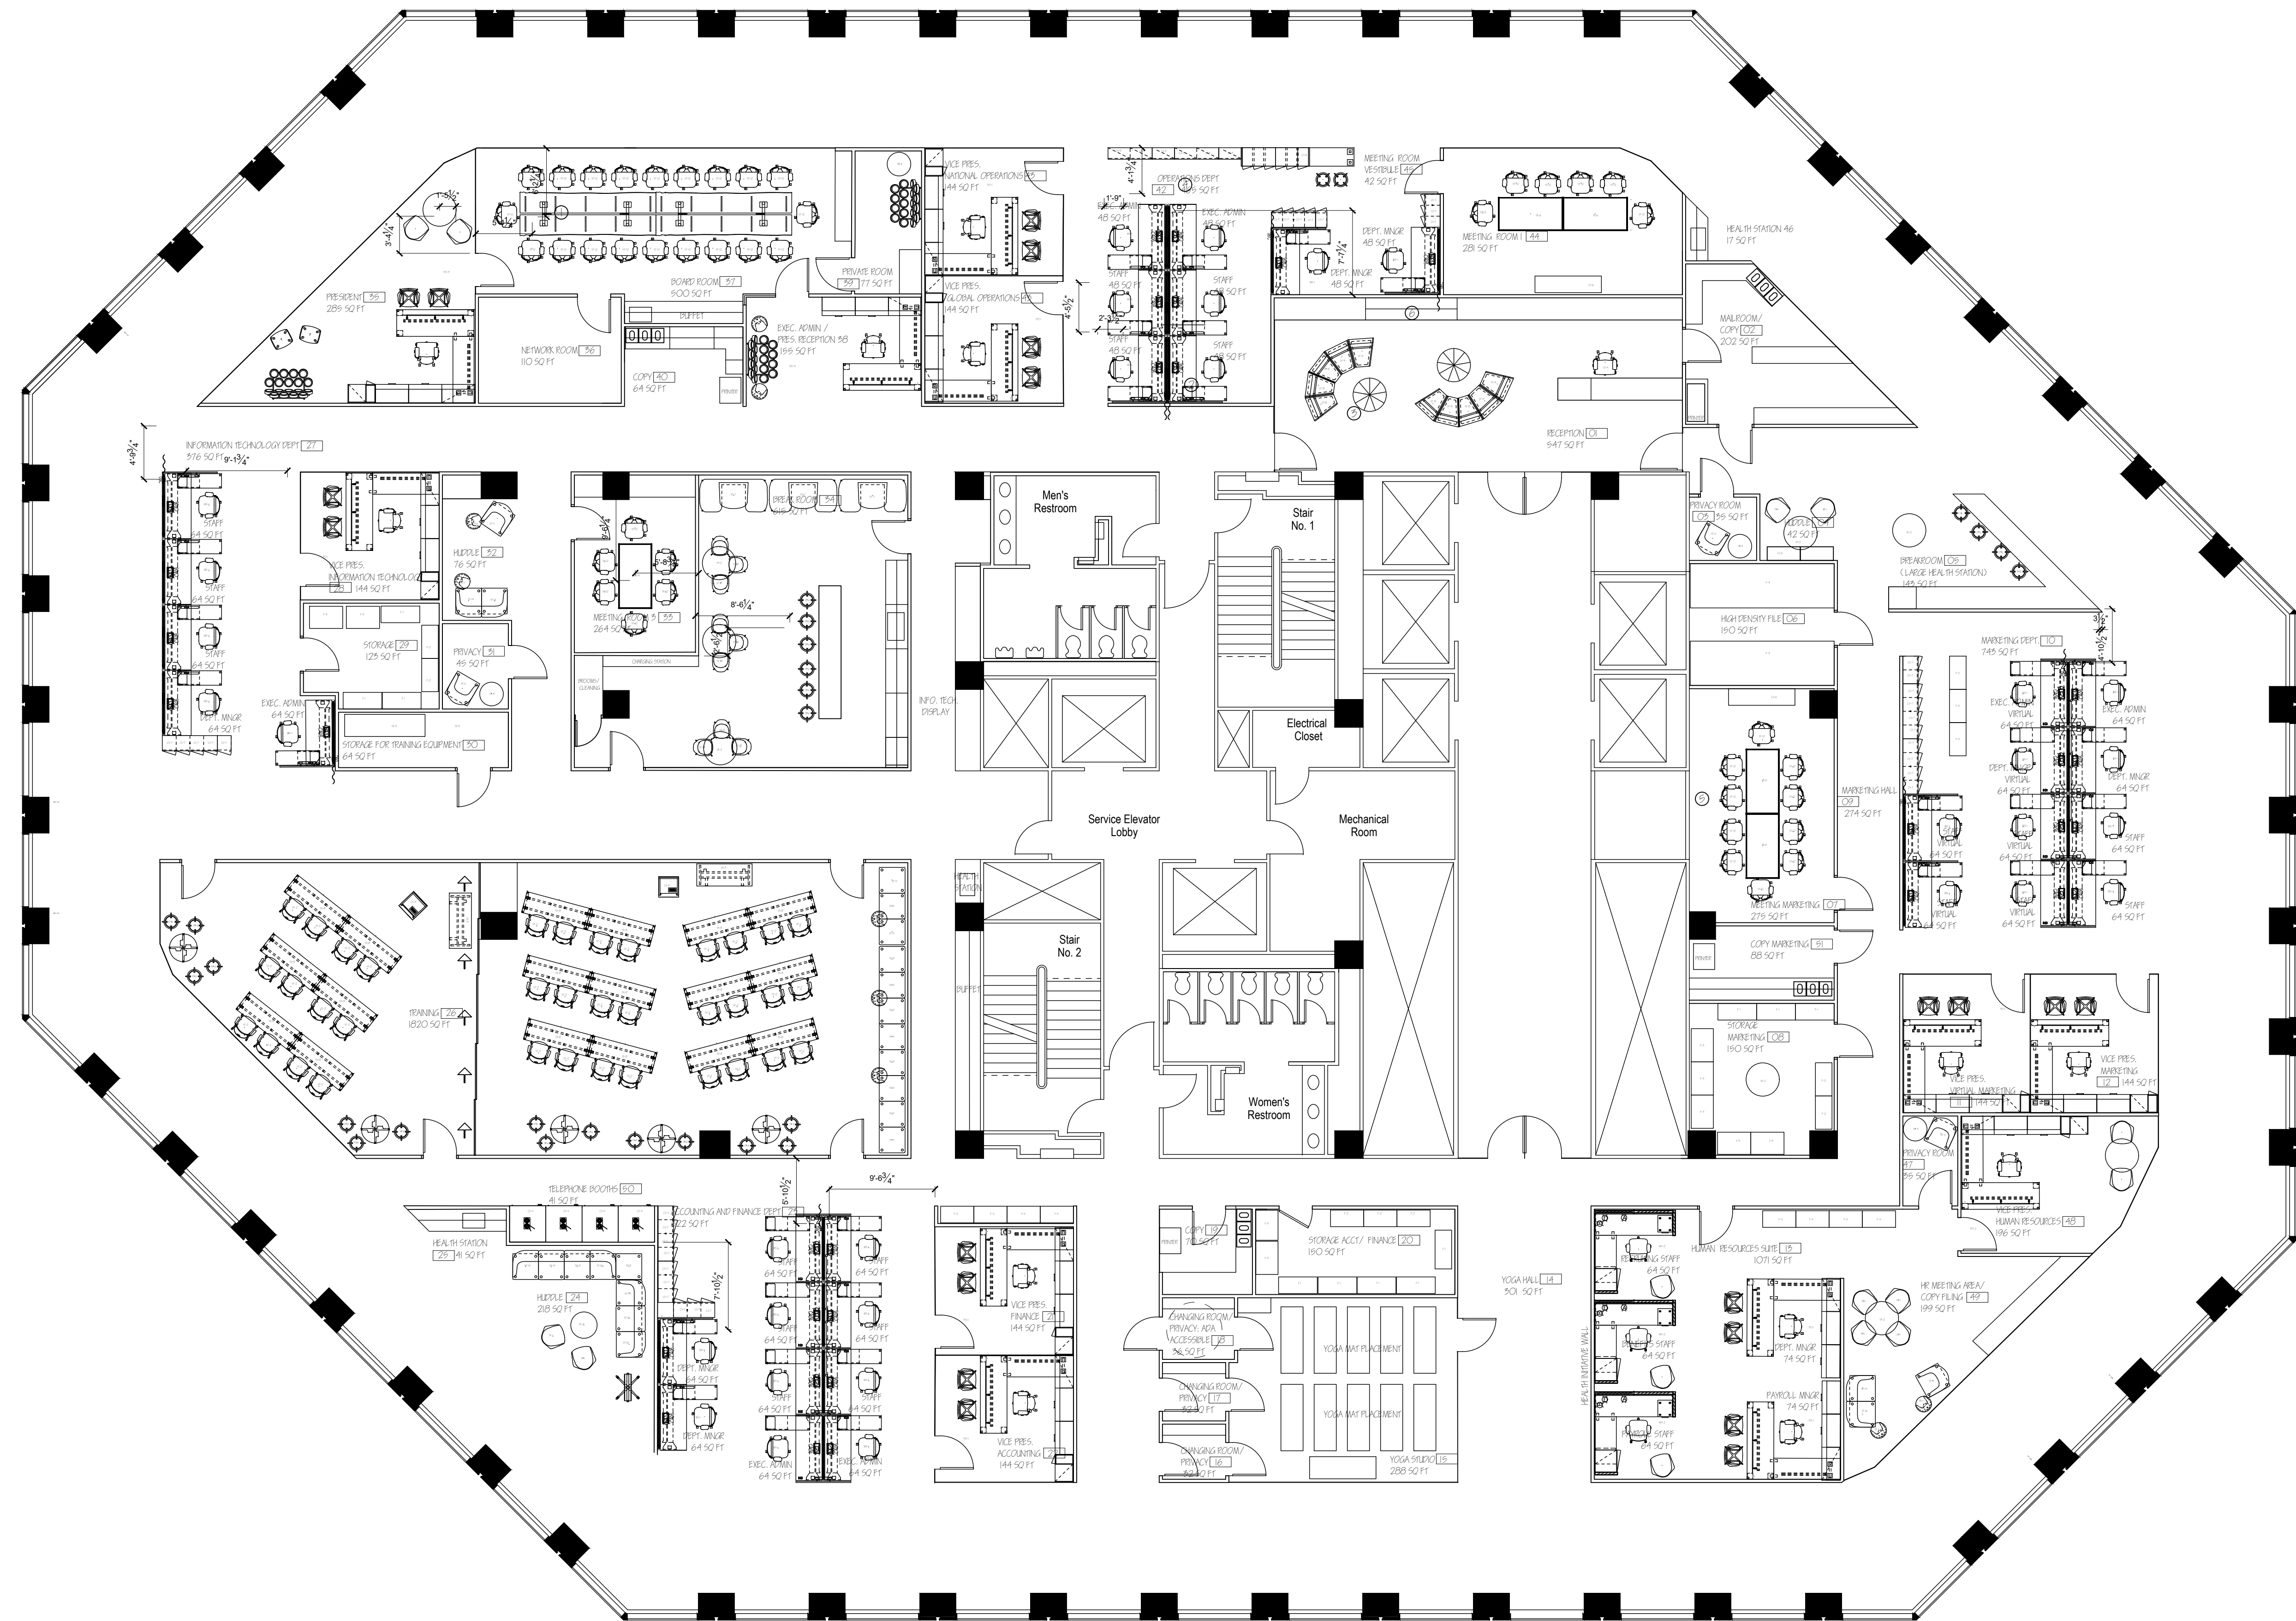

1 FURNITURE PLAN FOR FITBIT CORPORATE HEADQUARTERS
SCALE: N/A

